


AREA TABULATION	
FLOOR PLAN	2,000
TOTAL AIR CONDITIONED SPACE	2,000
SHOP	1,200
COVERED PORCH	1,144
TOTAL COVERED AREA	4,344

NOTE: WARNING:
are copyrighted and may not be used by others in whole or in part.

COPYRIGHT NOTICE: ALL PLANS PRESENTED IN THIS SET ARE PROTECTED BY COPYRIGHT. REPRODUCTION OF THESE PLANS, EITHER IN WHOLE OR IN PART FOR ANY REASON WITHOUT PRIOR WRITTEN PERMISSION FROM FLOW DESIGN FIRM IS PROHIBITED. NO OTHER REPRODUCTION, EITHER IN WHOLE OR IN PART, FOR ANY PURPOSE IS PERMITTED WITHOUT THE WRITTEN PERMISSION OF FLOW DESIGN FIRM. THIS SET OF PLANS IS INTENDED FOR A LIMITED LICENSE TO USE THE SET OF PLANS FOR THE CONSTRUCTION OF ONE STRUCTURE ONLY. ANY OTHER REPRODUCTION OR USE OF THESE PLANS FOR ANY OTHER PURPOSES WITHOUT CONSENT FROM FLOW DESIGN FIRM IS PROHIBITED. FLOW DESIGN FIRM DOES NOT CONVEY TO THE BUYER A LICENSE TO CONSTRUCT MORE THAN ONE DWELLING.

DISCLAIMER: SUBSTANTIAL EFFORT & CARE HAS BEEN PUT INTO THE DESIGN OF THESE PLANS. HOWEVER, SINCE WE CANNOT PROVIDE "ON-SITE" CONSULTATION, SUPERVISION, OR CONTROL OVER THE ACTUAL CONSTRUCTION AND BECAUSE OF VARIANCES IN LOCAL BUILDING CODES & REQUIREMENTS, BUILDING PRACTICES AND SOIL, WEATHER, MEASUREMENTS AND OTHER CONDITIONS WE CANNOT MAKE ANY WARRANTY, EXPRESSED OR IMPLIED. THE DESIGNER ASSUMES NO RESPONSIBILITIES FOR DAMAGES, INCLUDING STRUCTURAL FAILURES DUE TO ANY DEFICIENCIES, ERRORS OR OMISSIONS IN THE DESIGN OF THESE PLANS. IT IS RECOMMENDED THAT BEFORE YOU START, CONSULT A CERTIFIED BUILDER OR ENGINEER OF YOUR CHOICE AND CHECK WITH YOUR LOCAL BUILDING OFFICIALS.

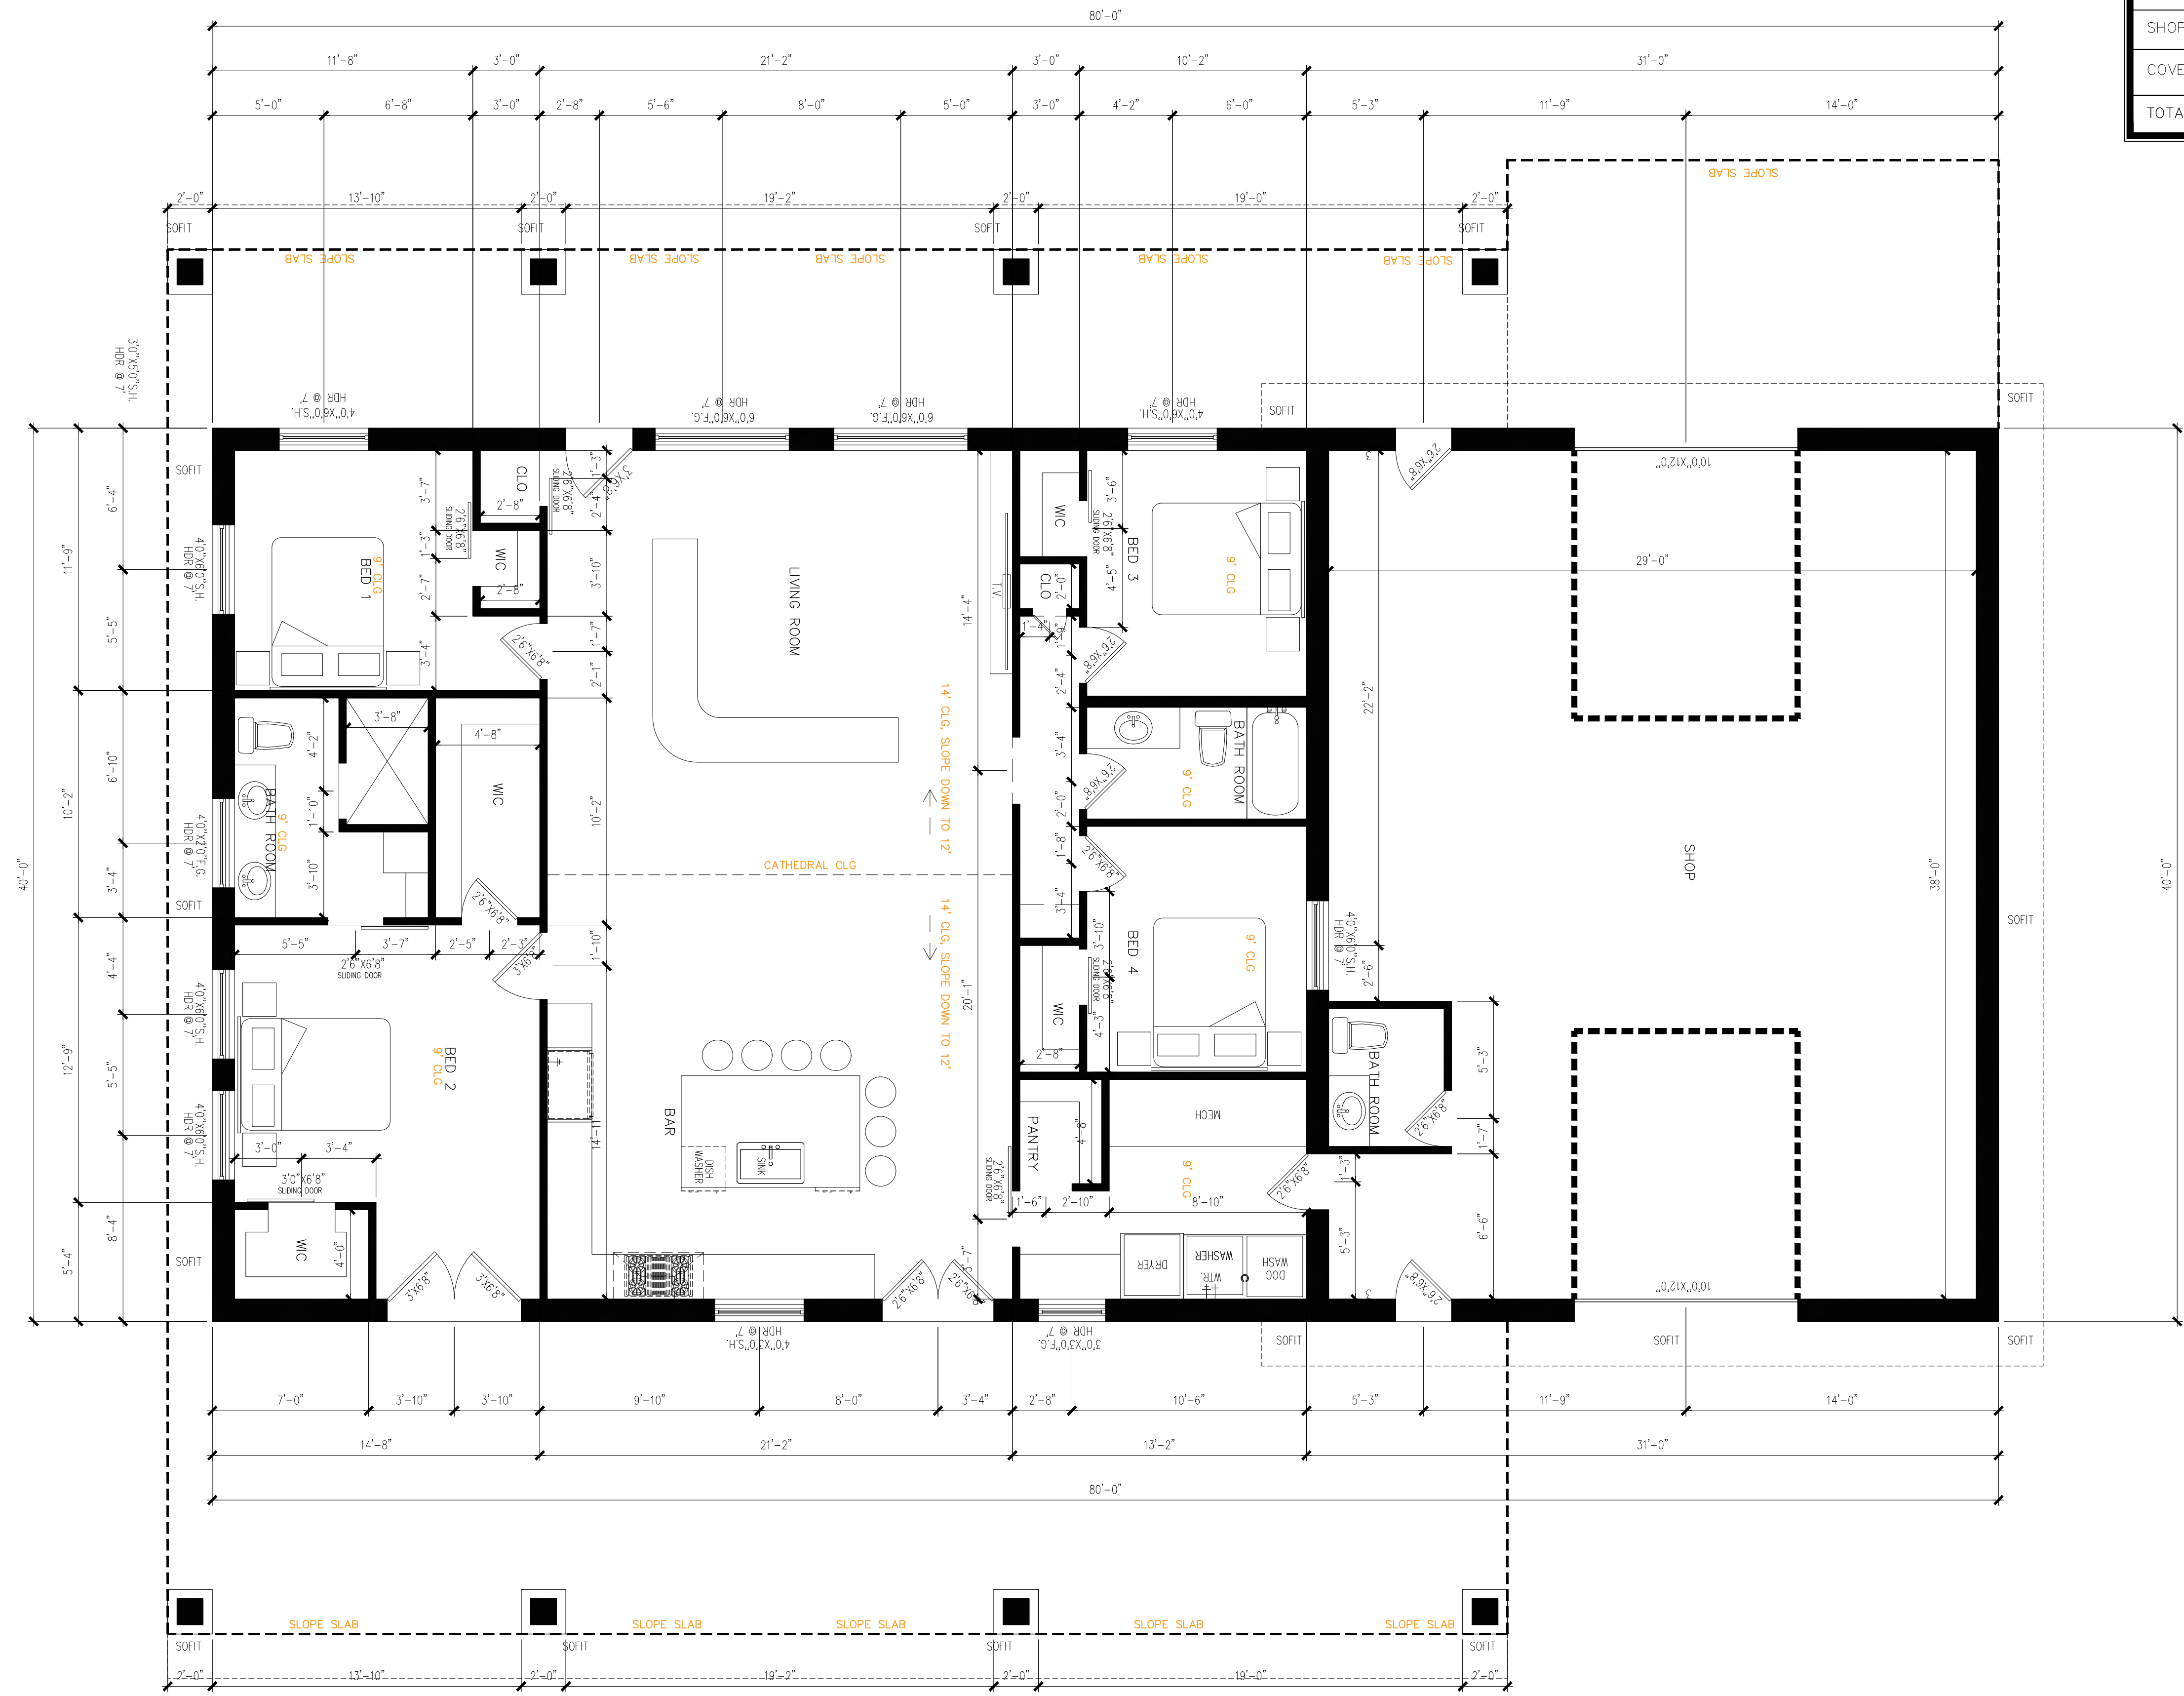

FIRST FLOOR PLAN
SCALE: 1/4"=1'-0"

JON JENKINS

SHEET TITLE
FLOOR PLAN

DESIGN FIRM
BARNDOPLANS.COM

A.1

SHEET: 1 OF 4

FINAL SET

NOTE: WARNING:
are copyrighted and may not be used
by others in whole or in part.

COPYRIGHT NOTICE: ALL PLANS PRESENTED IN THIS SET ARE PROTECTED BY COPYRIGHT. REPRODUCTION OF THESE PLANS, EITHER IN WHOLE OR IN PART FOR ANY REASON WITHOUT PRIOR WRITTEN PERMISSION FROM JON JENKINS DESIGN FIRM IS STRICTLY PROHIBITED. ANY UNAUTHORIZED REPRODUCTION OR DISTRIBUTION OF THESE PLANS IS PROHIBITED. ANY CONTRACTOR OR OTHER PROFESSIONAL SHALL BE RESPONSIBLE FOR OBTAINING ALL NECESSARY PERMITS AND LICENSES FOR THE CONSTRUCTION OF THE PROJECT. THE DESIGNER ASSUMES NO RESPONSIBILITY FOR DAMAGES, INCLUDING STRUCTURAL FAILURES DUE TO ANY DEPENDENCIES, ERRORS OR OMISSIONS IN THE DESIGN OF THESE PLANS. IT IS RECOMMENDED THAT BEFORE YOU START, CONSULT A CERTIFIED BUILDER OR ENGINEER OF YOUR CHOICE AND CHECK WITH YOUR LOCAL BUILDING OFFICIALS.

DESIGNER: SUBSTANTIAL EFFORT & CARE HAS BEEN PUT INTO THE DESIGN OF THESE PLANS. HOWEVER, SINCE WE CANNOT PROVIDE ON-SITE CONSULTATION, SUPERVISION, OR CONTROL OVER THE ACTUAL CONSTRUCTION AND BECAUSE OF VARIANCES IN LOCAL BUILDING CODES & REQUIREMENTS, BUILDING PRACTICES AND LOCAL WEATHER, MATERIALS AND OTHER CONDITIONS WE CANNOT MAKE ANY WARRANTY, EXPRESSED OR IMPLIED. THE DESIGNER ASSUMES NO RESPONSIBILITY FOR DAMAGES, INCLUDING STRUCTURAL FAILURES DUE TO ANY DEPENDENCIES, ERRORS OR OMISSIONS IN THE DESIGN OF THESE PLANS. IT IS RECOMMENDED THAT BEFORE YOU START, CONSULT A CERTIFIED BUILDER OR ENGINEER OF YOUR CHOICE AND CHECK WITH YOUR LOCAL BUILDING OFFICIALS.



ELECTRICAL PLAN
SCALE: 1/4"=1'-0"

JON JENKINS


SHEET TITLE
ELECTRICAL PLAN

FLOW
DESIGN FIRM
BARNDOPLANS.COM


A.2

SHEET: 2 OF 4


FINAL SET

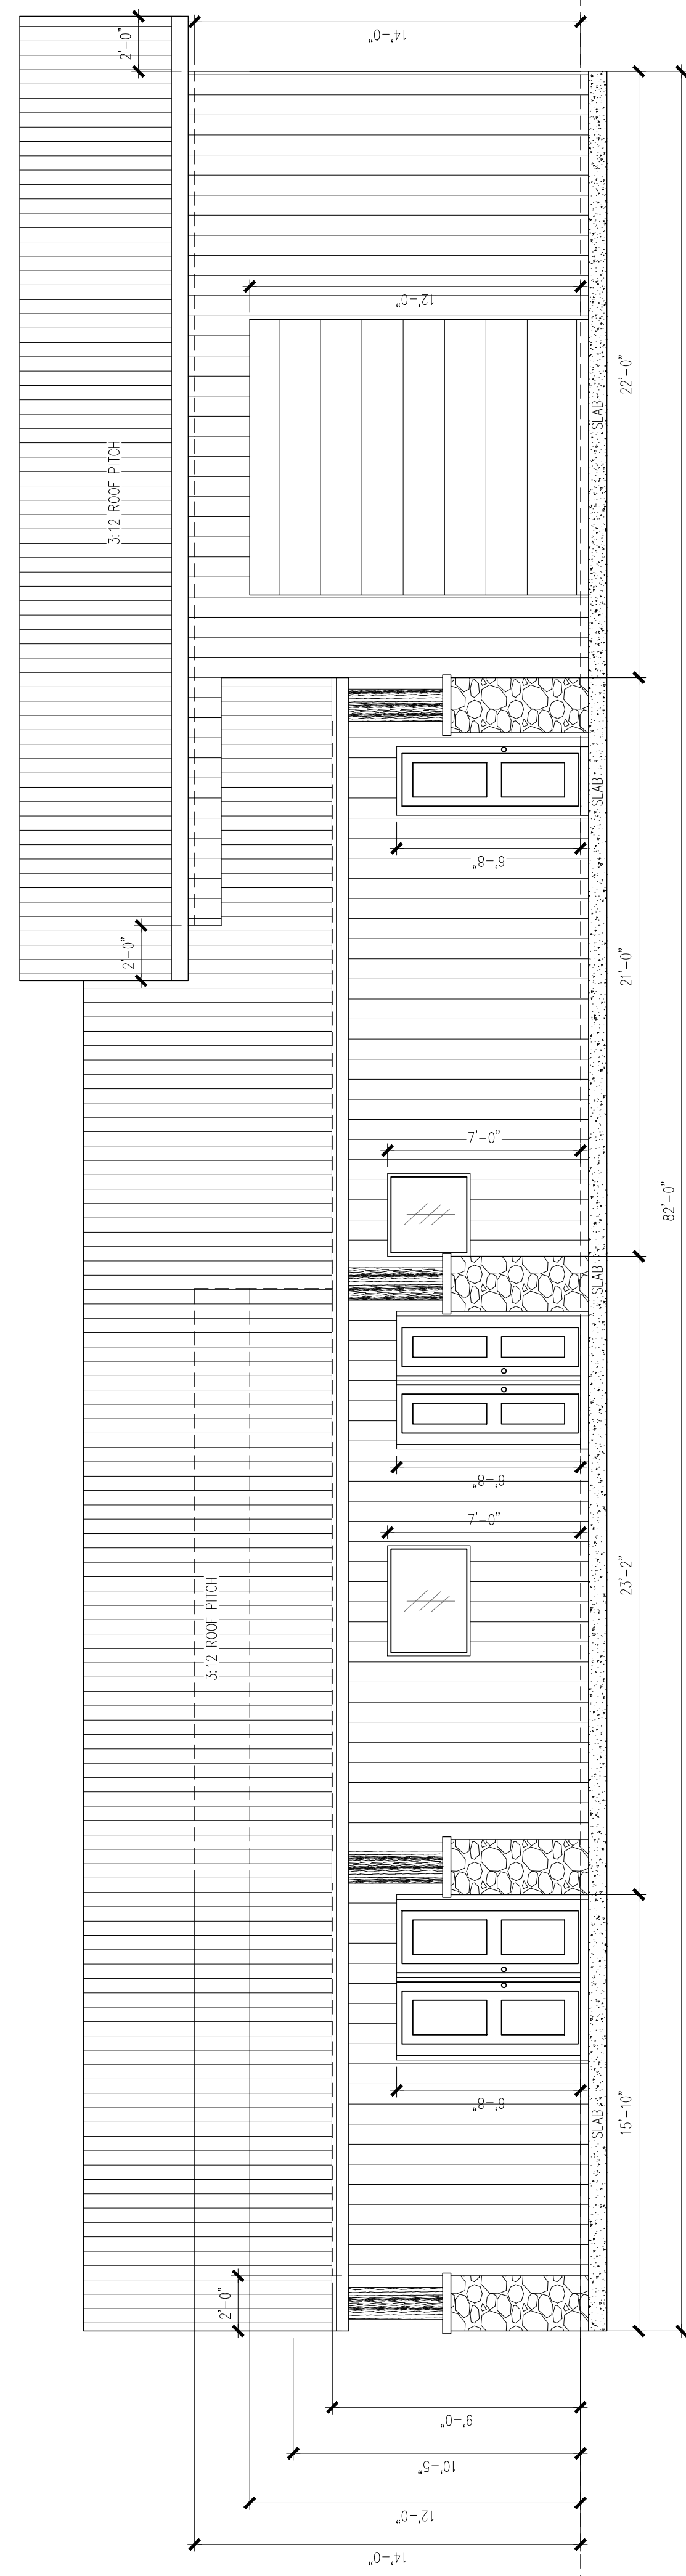


FRONT ELEVATION
SCALE: 1/4"=1'-0"

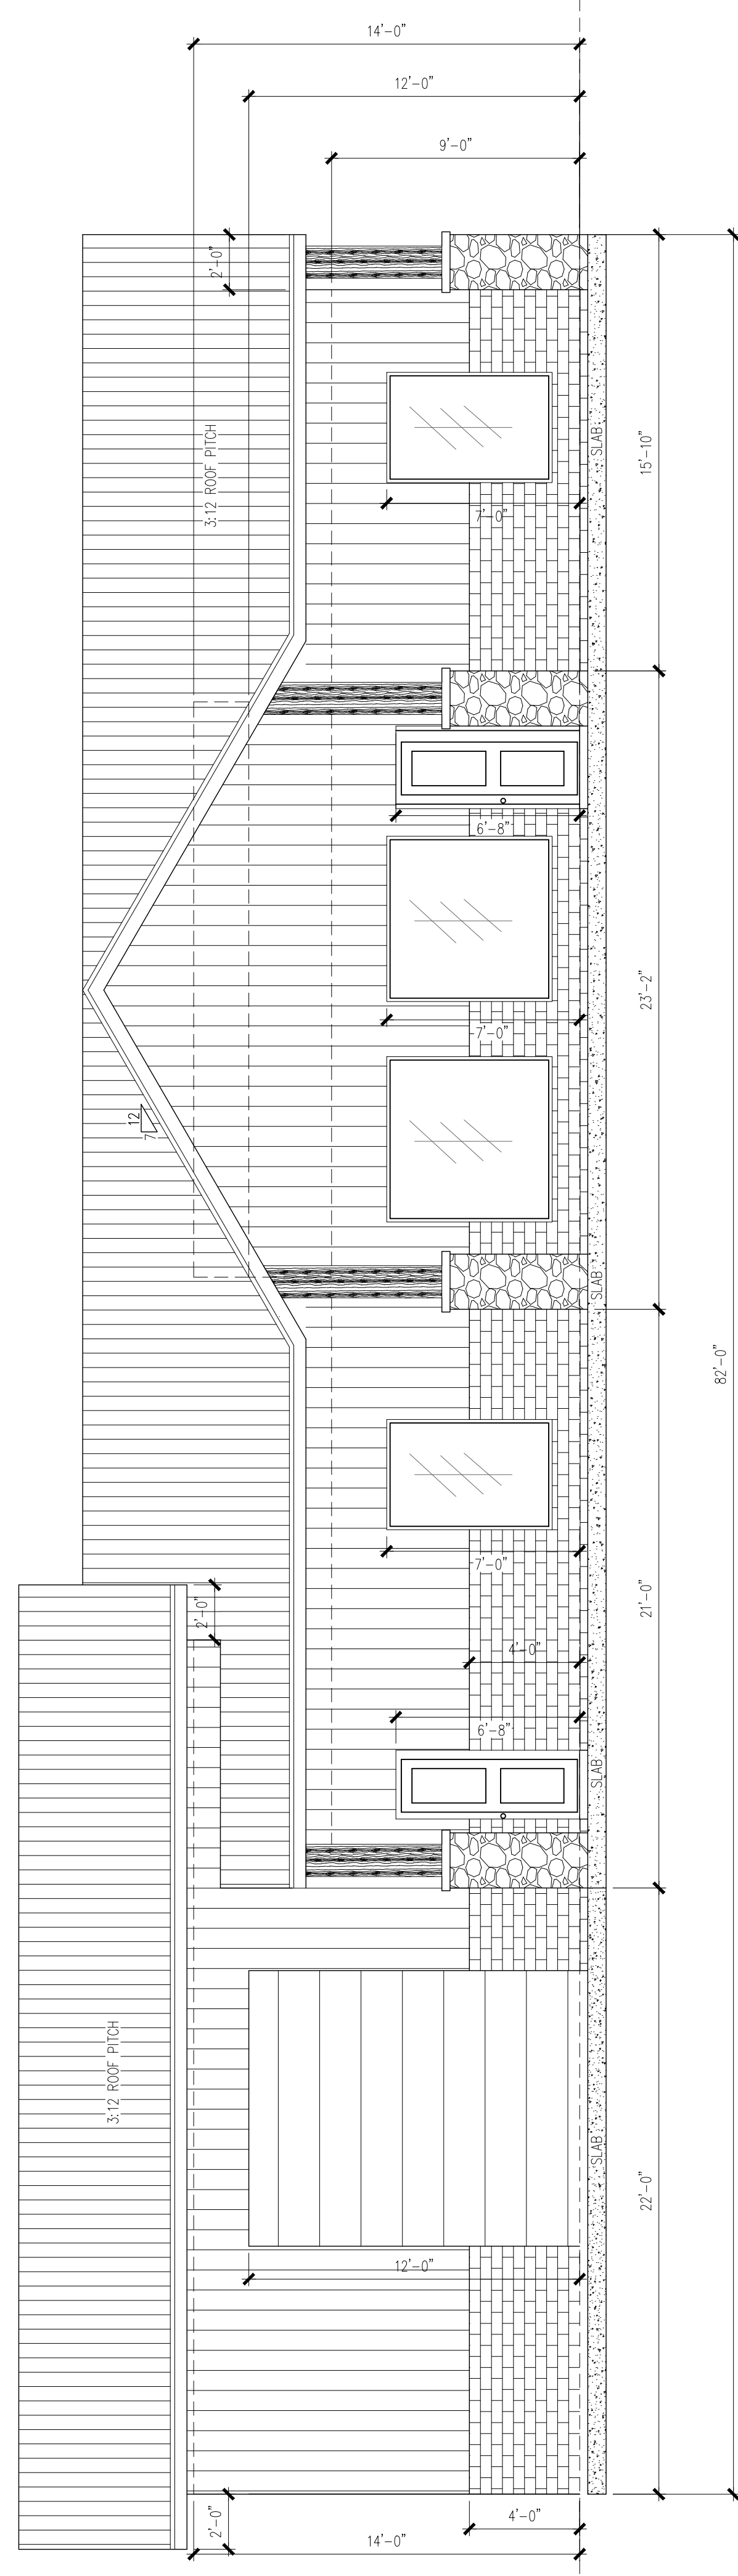

REAR ELEVATION
SCALE: 1/4"=1'-0"

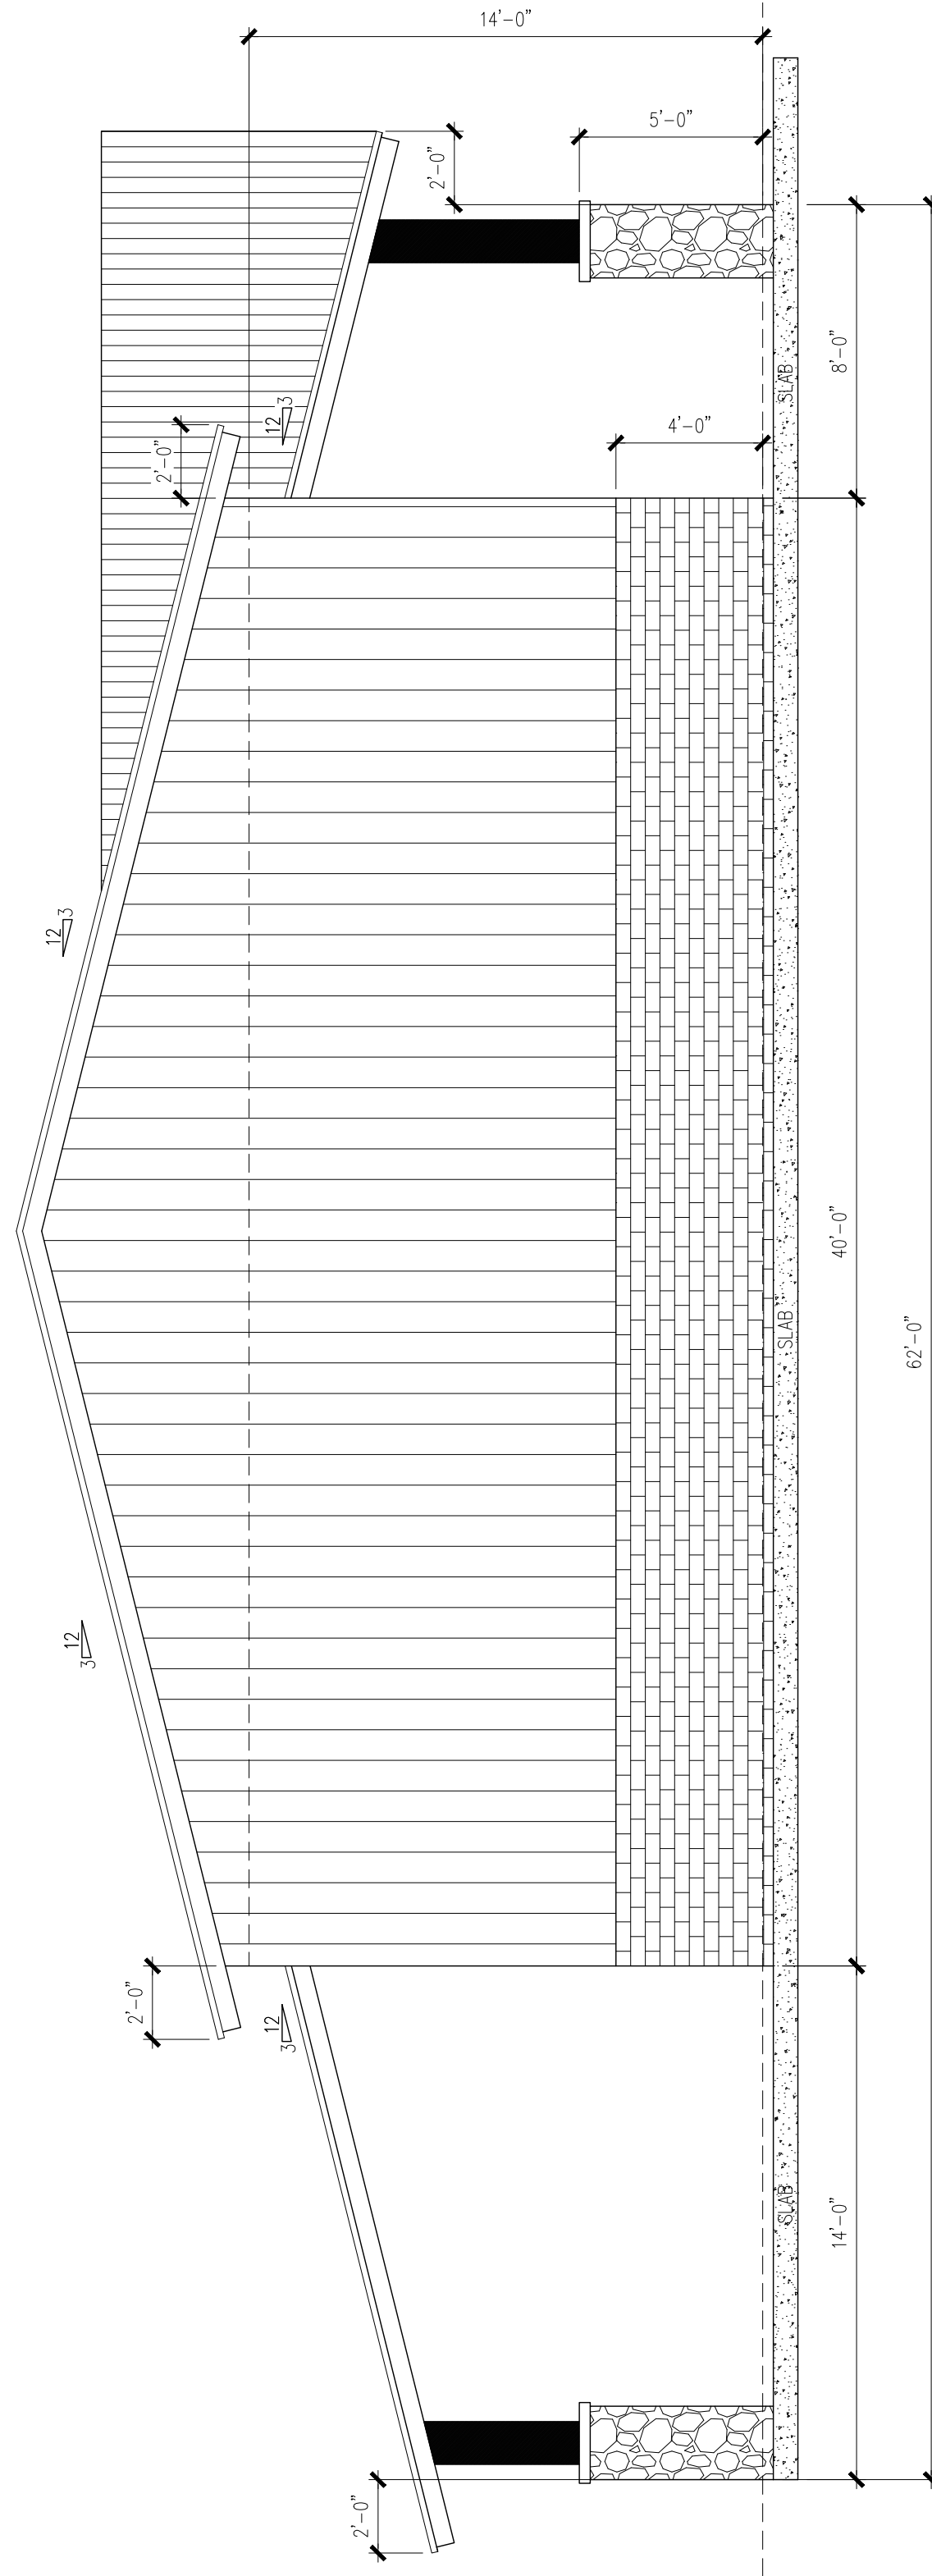

RIGHT ELEVATION
SCALE: 1/4"=1'-0"

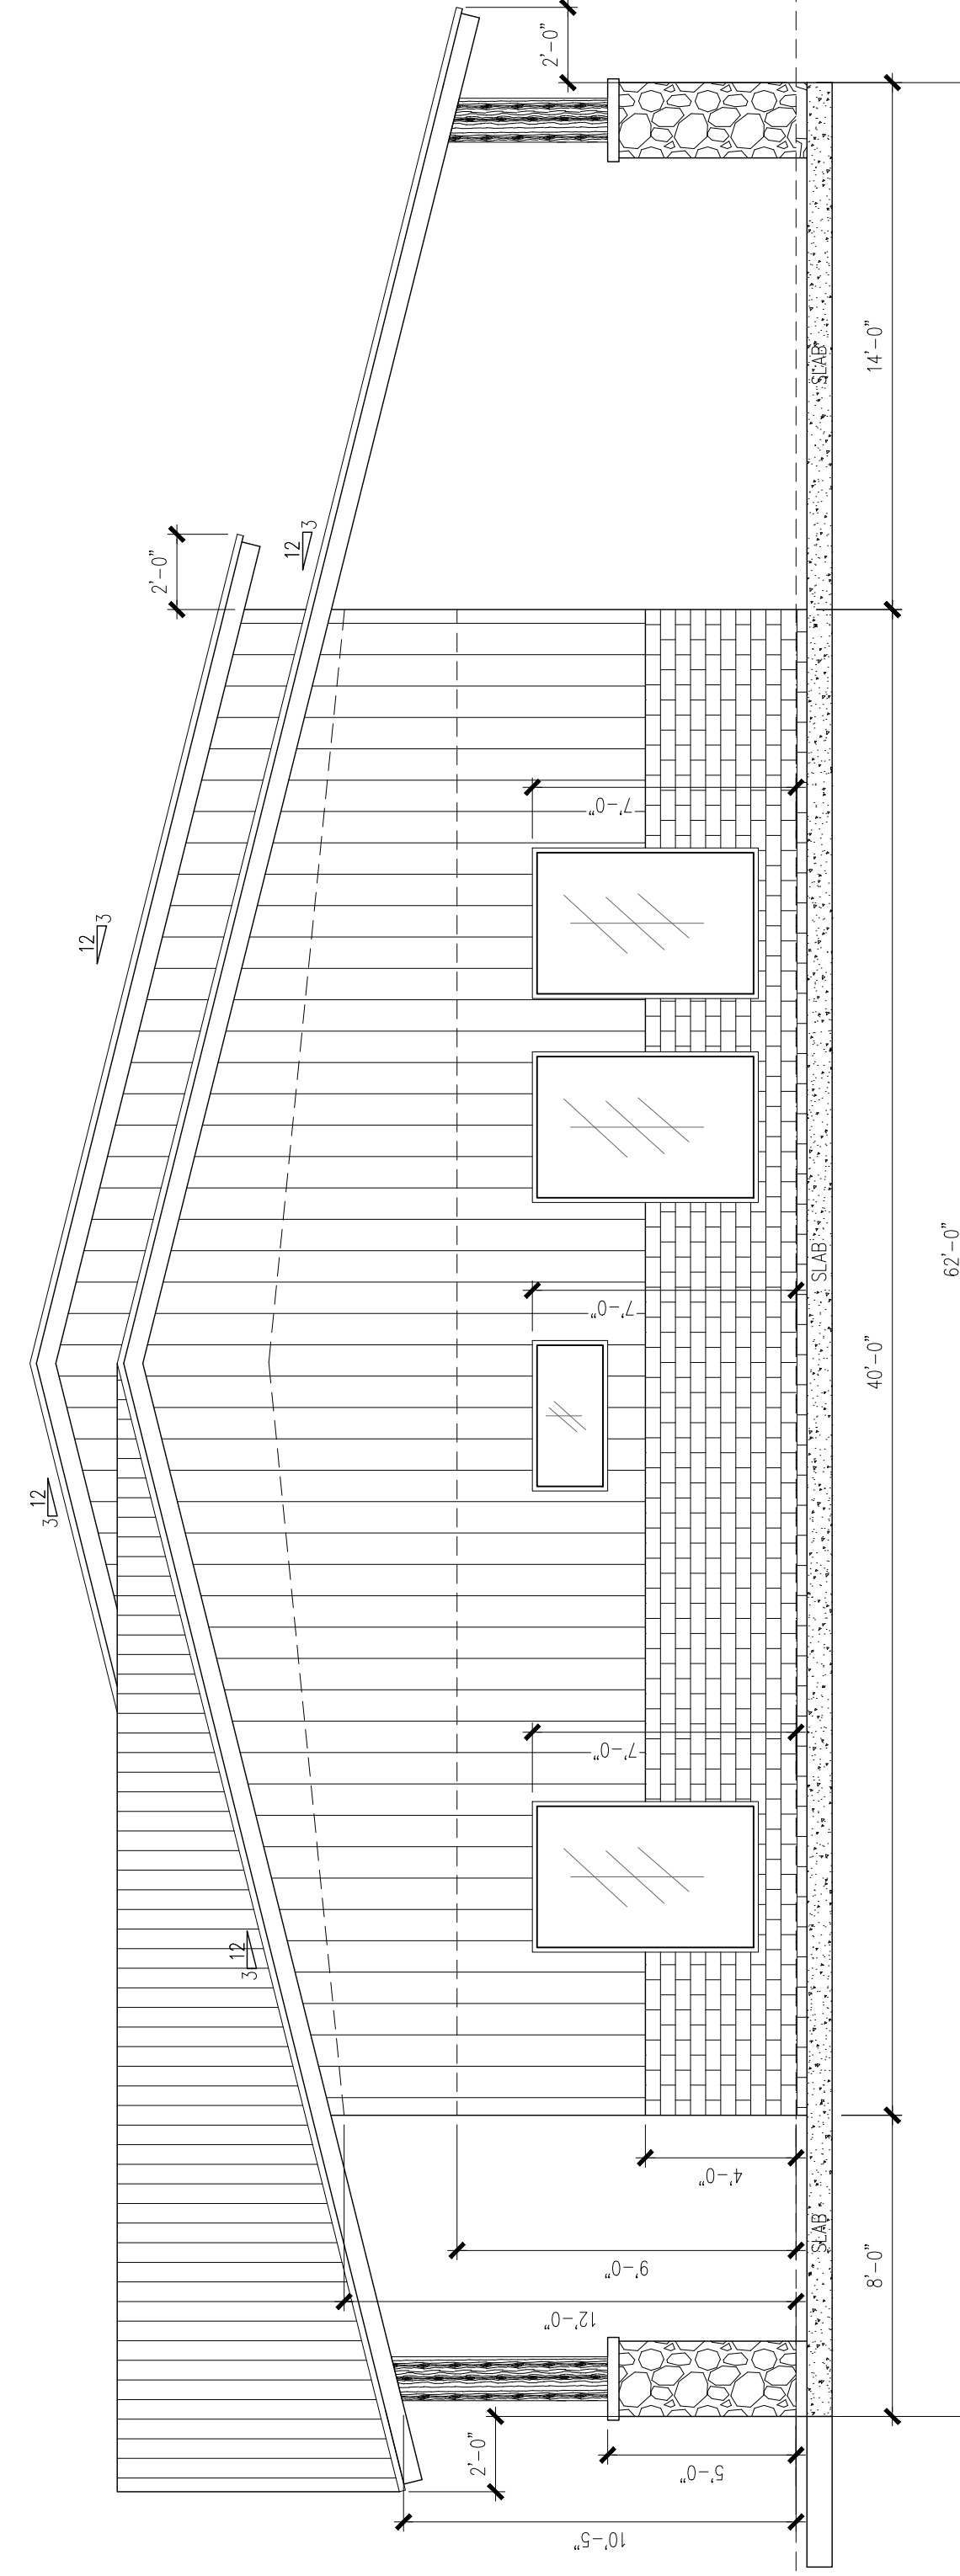

LEFT ELEVATION
SCALE: 1/4"=1'-0"

NOTE: WARNING:
are copyrighted and may not be used by others in whole or in part.

COPYRIGHT NOTICE: ALL PLANS PRESENTED IN THIS SET ARE PROTECTED BY COPYRIGHT. REPRODUCTION OF THESE PLANS, EITHER IN WHOLE OR IN PART FOR ANY REASON WITHOUT WRITTEN PERMISSION FROM THE ARCHITECT IS PROHIBITED. THE ARCHITECT SHALL BE RESPONSIBLE FOR THE ACCURACY OF THE INFORMATION PROVIDED IN THESE PLANS. THE ARCHITECT'S LIABILITY IS LIMITED TO THE DESIGN OF THE PLANS AND THE CONSTRUCTION OF THE BUILDING. THE ARCHITECT DOES NOT CONVEY TO THE OWNER A LICENSE TO CONSTRUCT MORE THAN ONE BUILDING. THE ARCHITECT'S LIABILITY IS LIMITED TO THE DESIGN OF THE PLANS AND THE CONSTRUCTION OF THE BUILDING. THE ARCHITECT DOES NOT CONVEY TO THE OWNER A LICENSE TO CONSTRUCT MORE THAN ONE BUILDING.

DISCLAIMER: SUBSTANTIAL EFFORT AND CARE HAS BEEN PUT INTO THE DESIGN OF THESE PLANS. HOWEVER, SINCE WE CANNOT PROVIDE "ON-SITE" CONSULTATION, SUPERVISION, OR CONTROL OVER THE ACTUAL CONSTRUCTION AND RESULTS OF FINISHED WORK, LOCAL BUILDING CODES, REQUIREMENTS, BUILDING PRACTICES, AND SOIL, WEATHER, WATER AND OTHER CONDITIONS WE CANNOT MAKE ANY WARRANTY, EXPRESSED OR IMPLIED. THE DESIGNER ASSUMES NO RESPONSIBILITY FOR DAMAGES, INCLUDING STRUCTURAL FAILURES, DUE TO ANY DEFICIENCIES, OMISSIONS, OR ERRORS IN THE DESIGN OF THESE PLANS. IT IS RECOMMENDED THAT BEFORE YOU START CONSTRUCTION, YOU CONSULT A LICENSED ENGINEER OR ARCHITECT AND CHECK WITH YOUR LOCAL BUILDING OFFICIALS.

SHEET TITLE
EXTERIOR ELEVATIONS

FLOW
DESIGN FIRM
BANDOPANS.COM

A.3
SHEET: 3 OF 4


FINAL SET

JON JENKINS

NOTE: WARNING:
are copyrighted and may not be used by others in whole or in part.

COPYRIGHT NOTICE: ALL PLANS PRESENTED IN THIS SET ARE PROTECTED BY COPYRIGHT. REPRODUCTION OF THESE PLANS EITHER IN WHOLE OR IN PART FOR ANY REASON WITHOUT THE WRITTEN PERMISSION FROM THE DESIGNER IS PROHIBITED. THE LICENSEE SHALL BE RESPONSIBLE FOR OBTAINING ALL NECESSARY PERMITS AND A LIMITED LICENSE TO USE THIS SET OF PLANS FOR THE CONSTRUCTION OF ONE BUILDING ONLY. PROVIDING ANY ADDITIONAL SETS OR THE SAME CHANGES NOT CONVEY TO THE BUYER A LICENSE TO CONSTRUCT MORE THAN THE DRAWING.

DISCLAIMER: SUBSTANTIAL EFFORT & CARE HAS BEEN PUT INTO THE DESIGN OF THESE PLANS. HOWEVER, SINCE WE CANNOT PROVIDE "ON-SITE" CONSULTATION, SUPERVISION, OR CONTROL OVER THE ACTUAL CONSTRUCTION AND RESULTS OF FINISHED AS LOCAL BUILDING CODES & REQUIREMENTS, BUILDING PRACTICES AND SOIL, CLIMATE, WEATHER AND OTHER CONDITIONS WE CANNOT MAKE ANY WARRANTY, EXPRESSED OR IMPLIED. THE DESIGNER ASSUMES NO RESPONSIBILITIES FOR DAMAGES, INCLUDING STRUCTURAL FAILURES DUE TO ANY DEFICIENCIES, ERRORS OR OMISSIONS IN THE DESIGN OF THESE PLANS. IT IS RECOMMENDED THAT BEFORE YOU START, CONSULT A LICENSED ENGINEER OR ARCHITECT OF YOUR CHOICE AND CHECK WITH YOUR LOCAL BUILDING OFFICIALS.

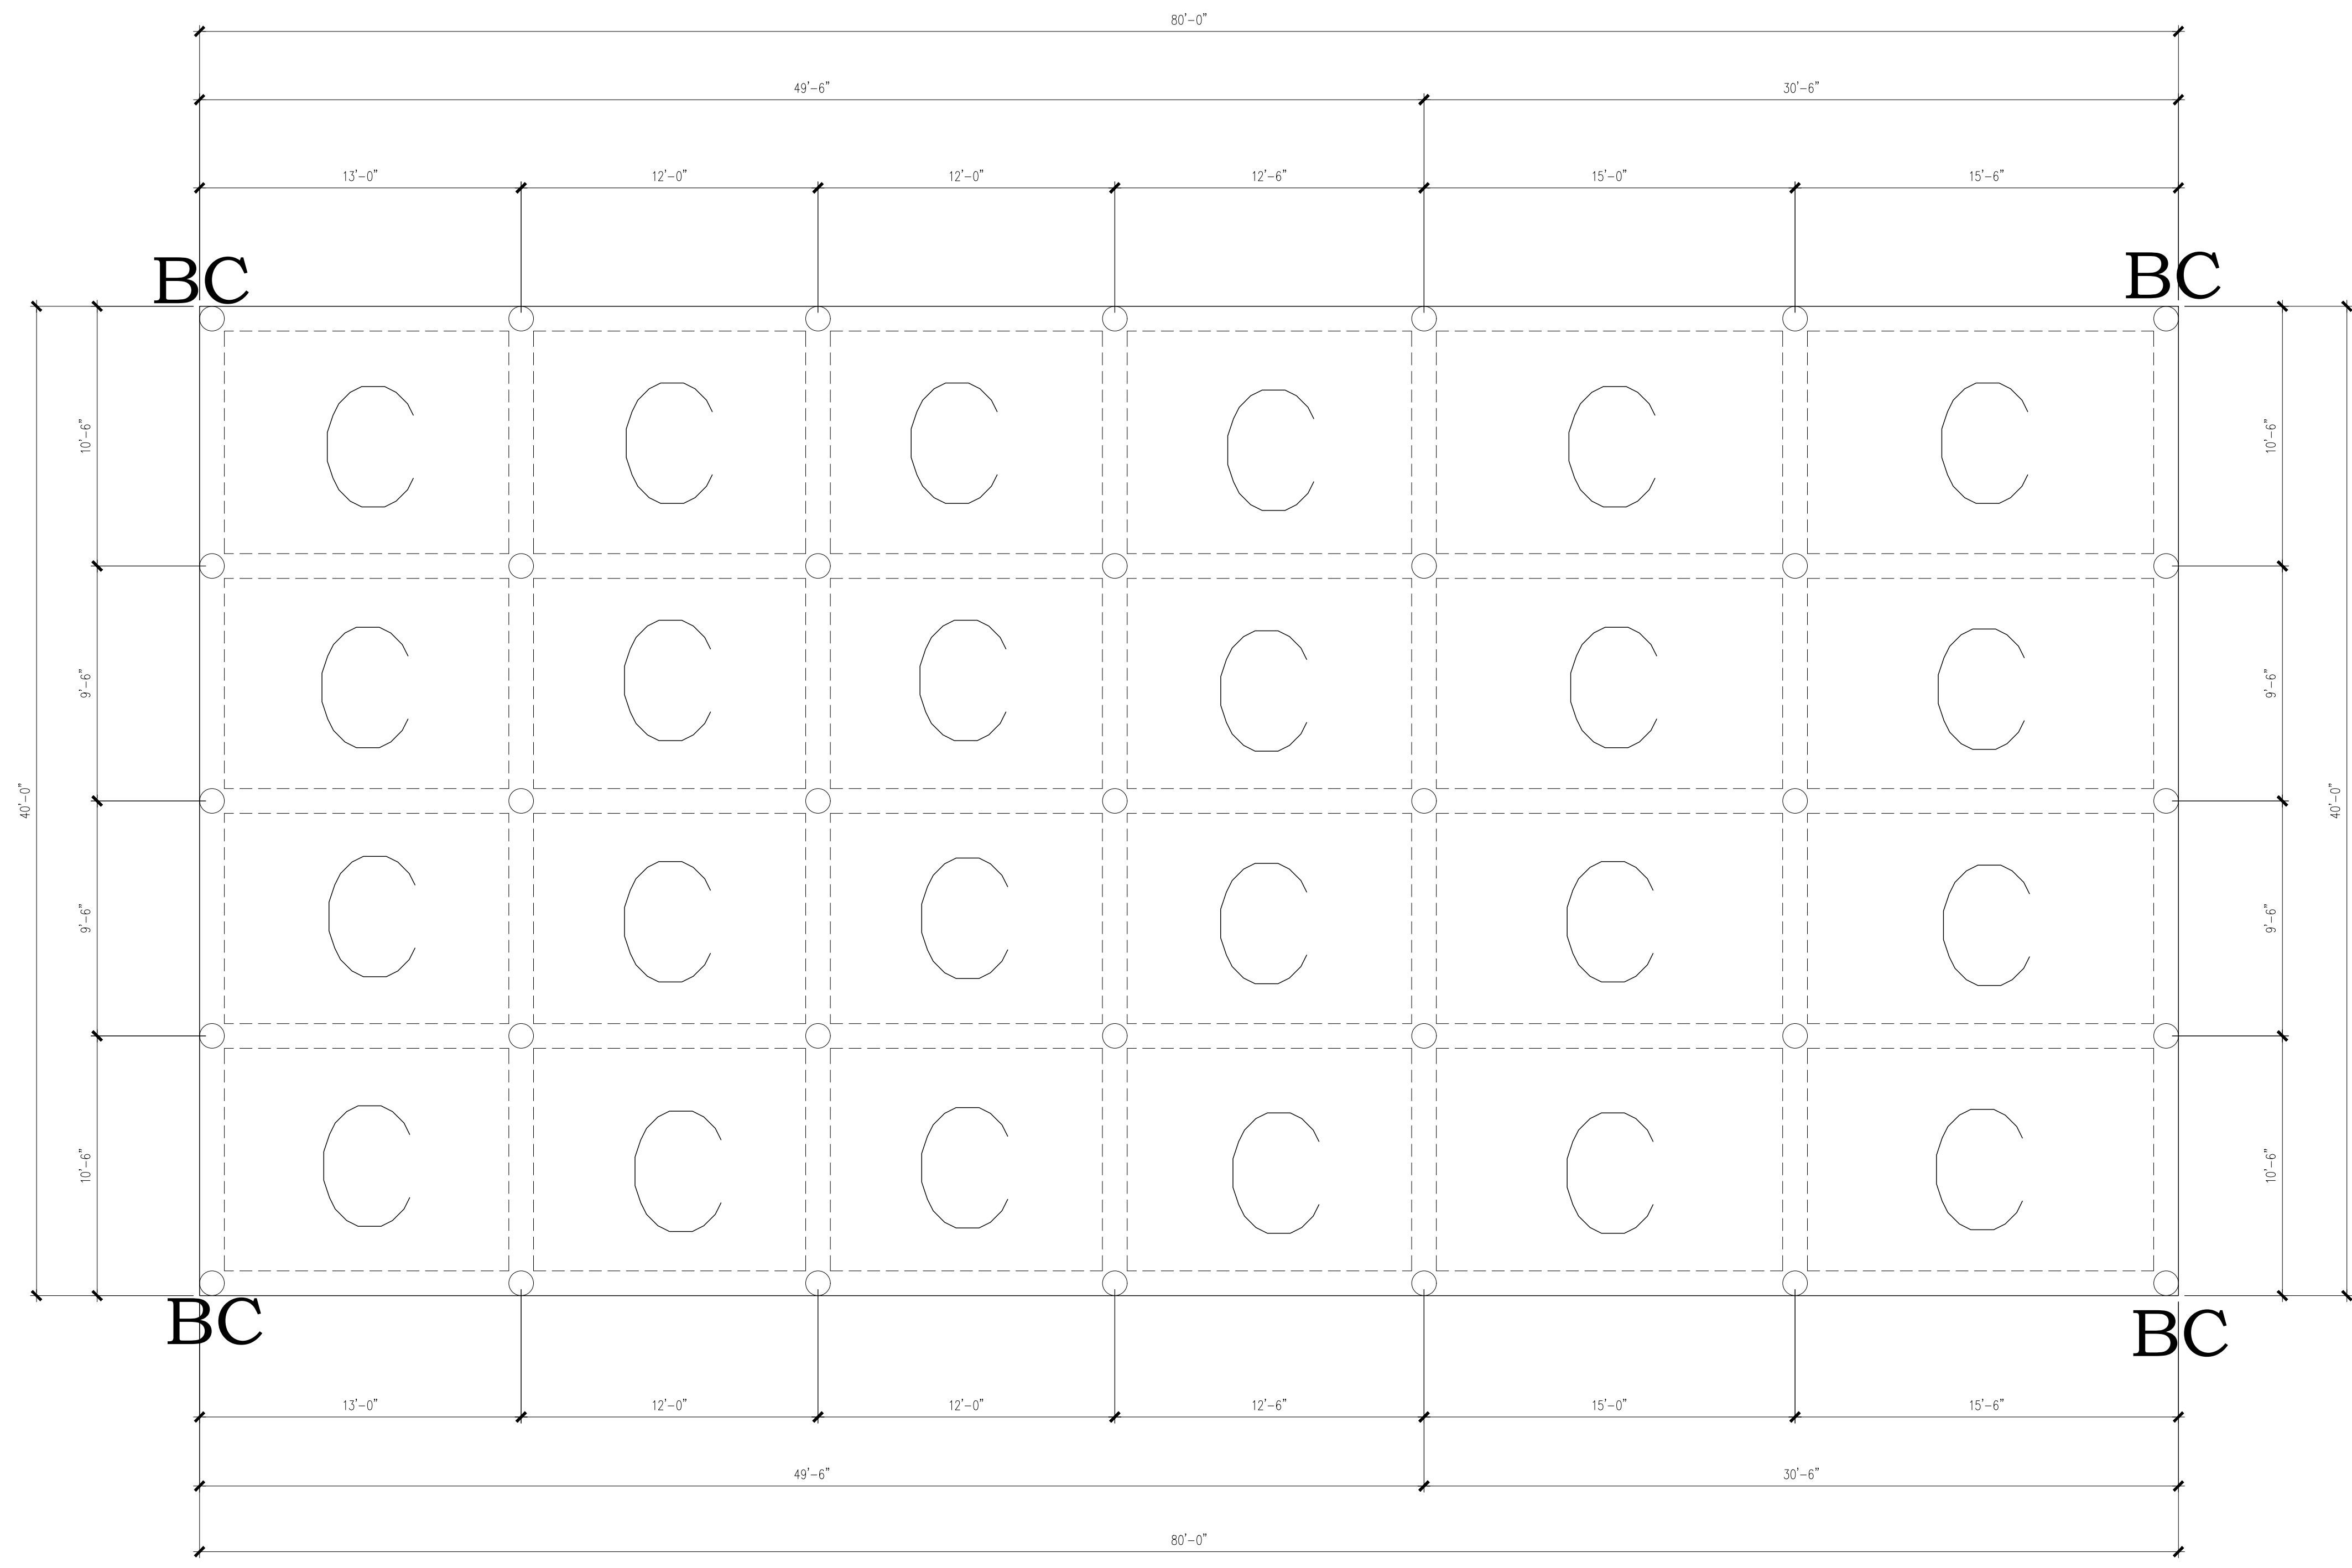

FOUNDATION PLAN
SCALE: 1/4"=1'-0"

JON JENKINS

SHEET TITLE
FOUNDATION PLAN

FLOW
DESIGN FIRM
BARNDOPLANS.COM

A 4
SHEET: 4 OF 4

FINAL SET