

DISCLAIMER: SUBSTANTIAL EFFORT & CARE HAS BEEN PUT INTO THE CREATION OF THE DESIGN OF THESE PLANS. HOWEVER, SINCE WE CANNOT PROVIDE 100% GUARANTEE, SUPERVISION, OR CONTROL OVER THE ACTUAL CONSTRUCTION AND RELEASE OF VARIANCES IN LOCAL BUILDING CODES & REQUIREMENTS, BUILDING PRACTICES AND LOCAL CLIMATE, WEATHER AND OTHER CONDITIONS WE CANNOT MAKE ANY WARRANTY, EXPRESSED OR IMPLIED. THE DESIGNER ASSUMES NO RESPONSIBILITIES FOR DAMAGES, INCLUDING STRUCTURAL FAILURES DUE TO ANY DEFICIENCIES, ERRORS OR OMISSIONS IN THE DESIGN OF THESE PLANS. IT IS RECOMMENDED THAT BEFORE YOU START, CONSULT A LICENSED ENGINEER OR ARCHITECT OF YOUR CHOICE AND CHECK WITH YOUR LOCAL BUILDING OFFICIALS.


DARIN DODD

SHEET TITLE
FLOOR PLAN

FLOW
DESIGN FIRM
BARNDOPLANS.COM

A 1


SHEET: 1 OF 5

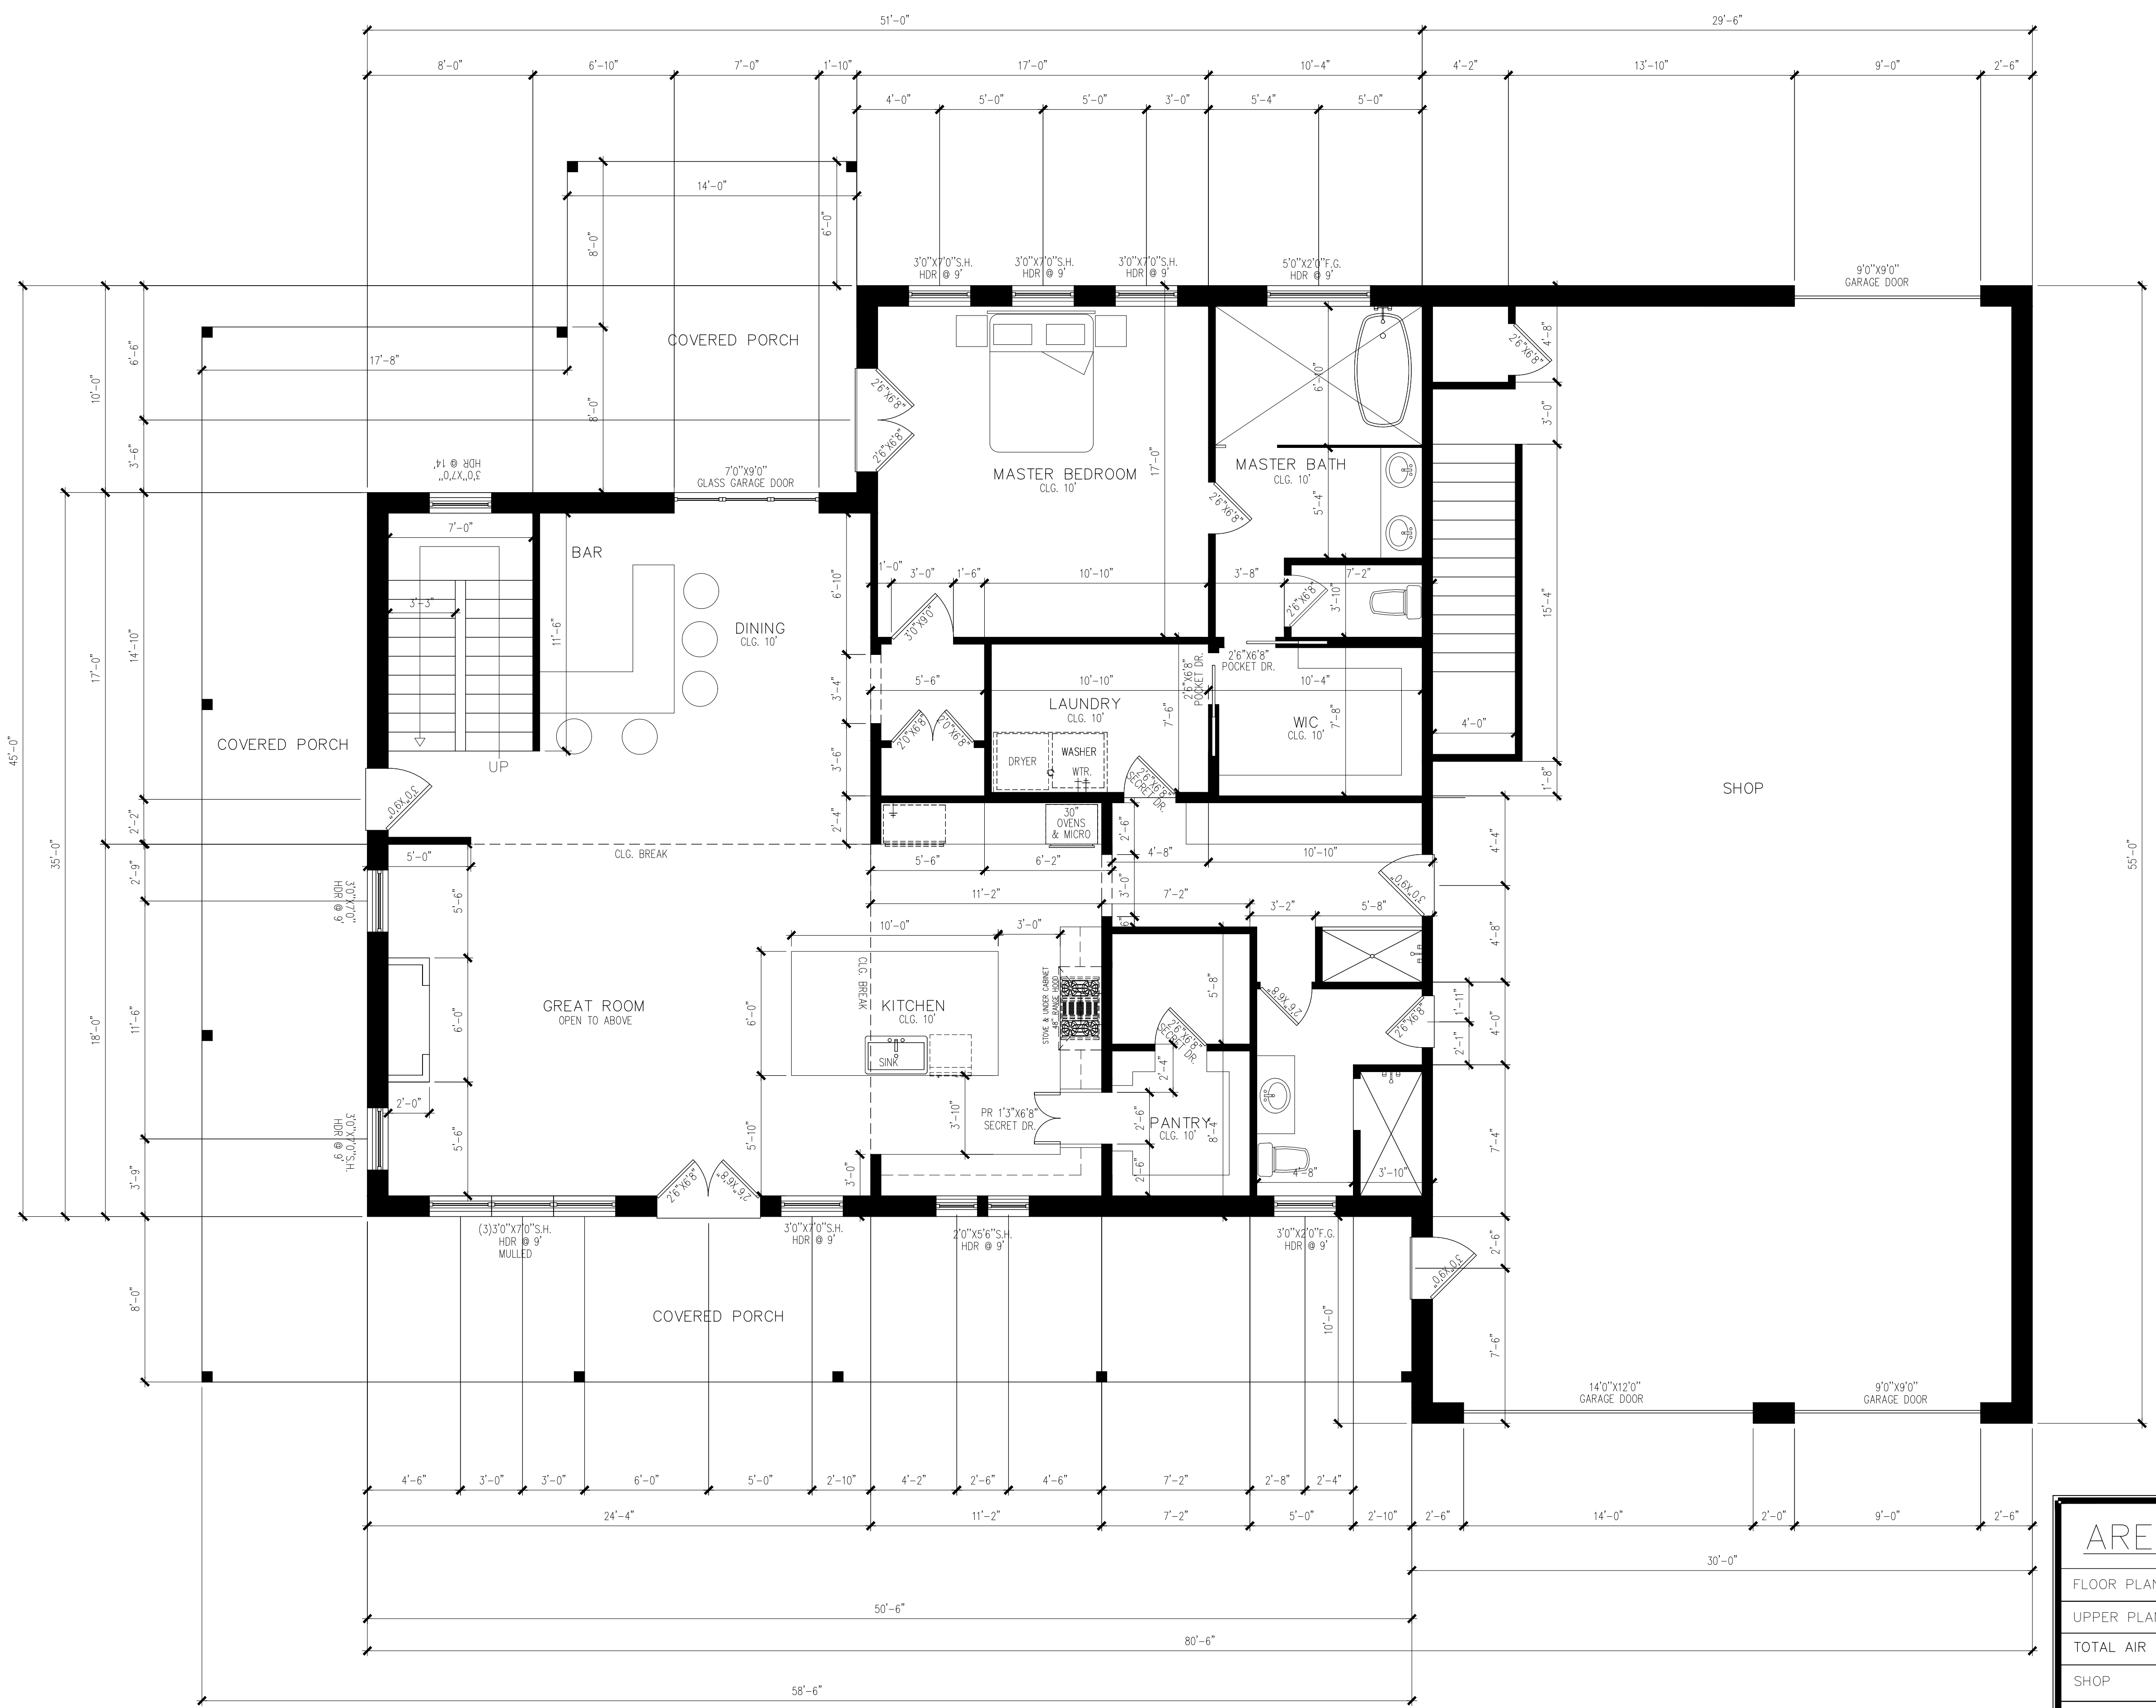

FIRST FLOOR PLAN
SCALE: 1/4"=1'-0"

AREA TABULATION	
FLOOR PLAN	2081
UPPER PLAN	1,649
TOTAL AIR CONDITIONED SPACE	3,730
SHOP	1,605
COVERED PORCH	1114
TOTAL COVERED AREA	6,449

DISCLAIMER: SUBSTANTIAL EFFORT & CARE HAS BEEN PUT INTO THE CREATION OF THE DESIGN OF THESE PLANS. HOWEVER, SINCE WE CANNOT PROVIDE ON-SITE CONSULTATION, SUPERVISION, OR CONTROL OVER THE ACTUAL CONSTRUCTION AND BECAUSE OF VARIANCES IN LOCAL BUILDING CODES & REQUIREMENTS, BUILDING PRACTICES AND SOIL, SEISMIC, WEATHER AND OTHER CONDITIONS WE CANNOT MAKE ANY WARRANTY, EXPRESSED OR IMPLIED. THE DESIGNER ASSUMES NO RESPONSIBILITIES FOR DAMAGES, INCLUDING STRUCTURAL FAILURES DUE TO ANY DEFICIENCIES, ERRORS OR OMISSIONS IN THE DESIGN OF THESE PLANS. IT IS RECOMMENDED THAT BEFORE YOU START, CONSULT A LICENSED BUILDER OR ENGINEER OF YOUR CHOICE AND CHECK WITH YOUR LOCAL BUILDING OFFICIALS.

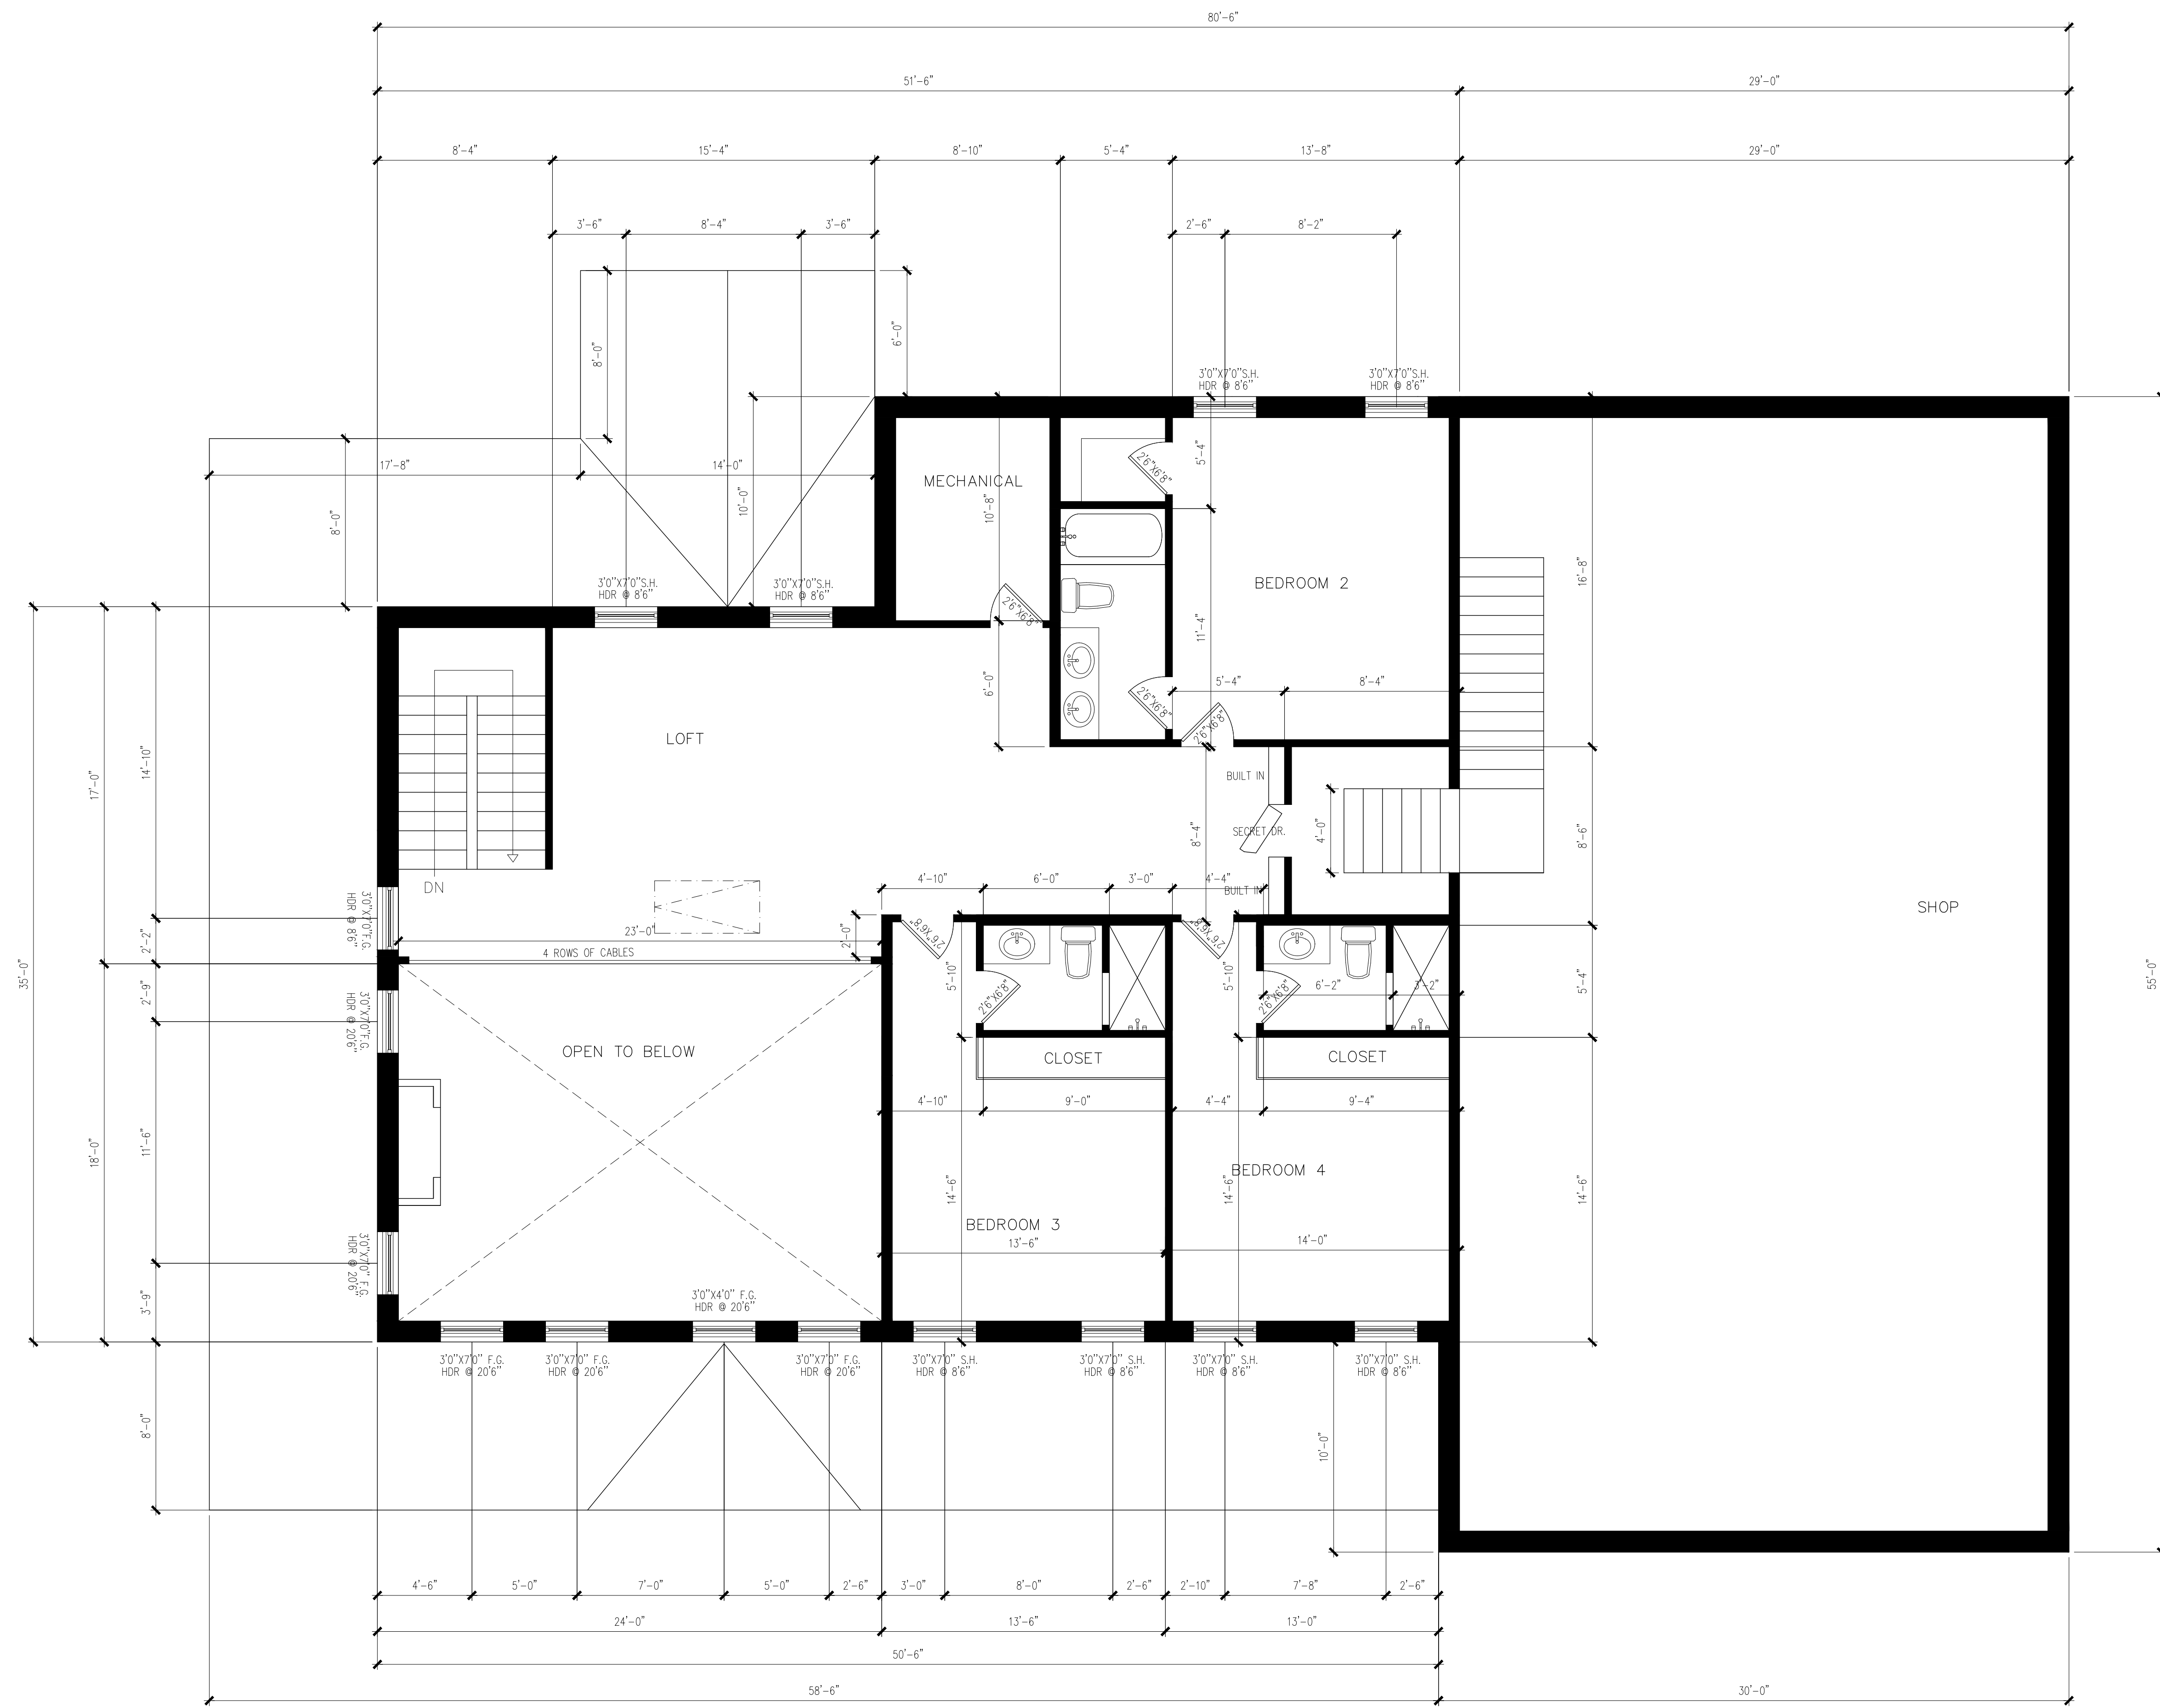


UPPER FLOOR PLAN
SCALE: 1/4"=1'-0"

DARIN DODD

SHEET TITLE
UPPER FLOOR PLAN
FLOW
DESIGN FIRM
BARNDOPLANS.COM

A.2
SHEET: 2 OF 5

DISCLAIMER: SUBSTANTIAL EFFORT & CARE HAS BEEN PUT INTO THE CREATION OF THESE PLANS. HOWEVER, SINCE WE CANNOT PROVIDE 100% SITE CONSULTATION, SUPERVISION, OR CONTROL OVER THE ACTUAL CONSTRUCTION AND BECAUSE OF VARIANCES IN LOCAL BUILDING CODES & REQUIREMENTS, BUILDING PRACTICES AND SOIL, SEISMIC, WEATHER AND OTHER CONDITIONS, WE CANNOT MAKE ANY WARRANTY, EXPRESSED OR IMPLIED. THE DESIGNER ASSUMES NO RESPONSIBILITY FOR DAMAGES, INCLUDING STRUCTURAL FAILURES, DUE TO ANY DEPENDENCIES, ERRORS OR OMISSIONS IN THE DESIGN OF THESE PLANS. IT IS RECOMMENDED THAT BEFORE YOU START, CONSULT A LICENSED BUILDER OR ENGINEER OF YOUR CHOICE AND CHECK WITH YOUR LOCAL BUILDING OFFICIALS.

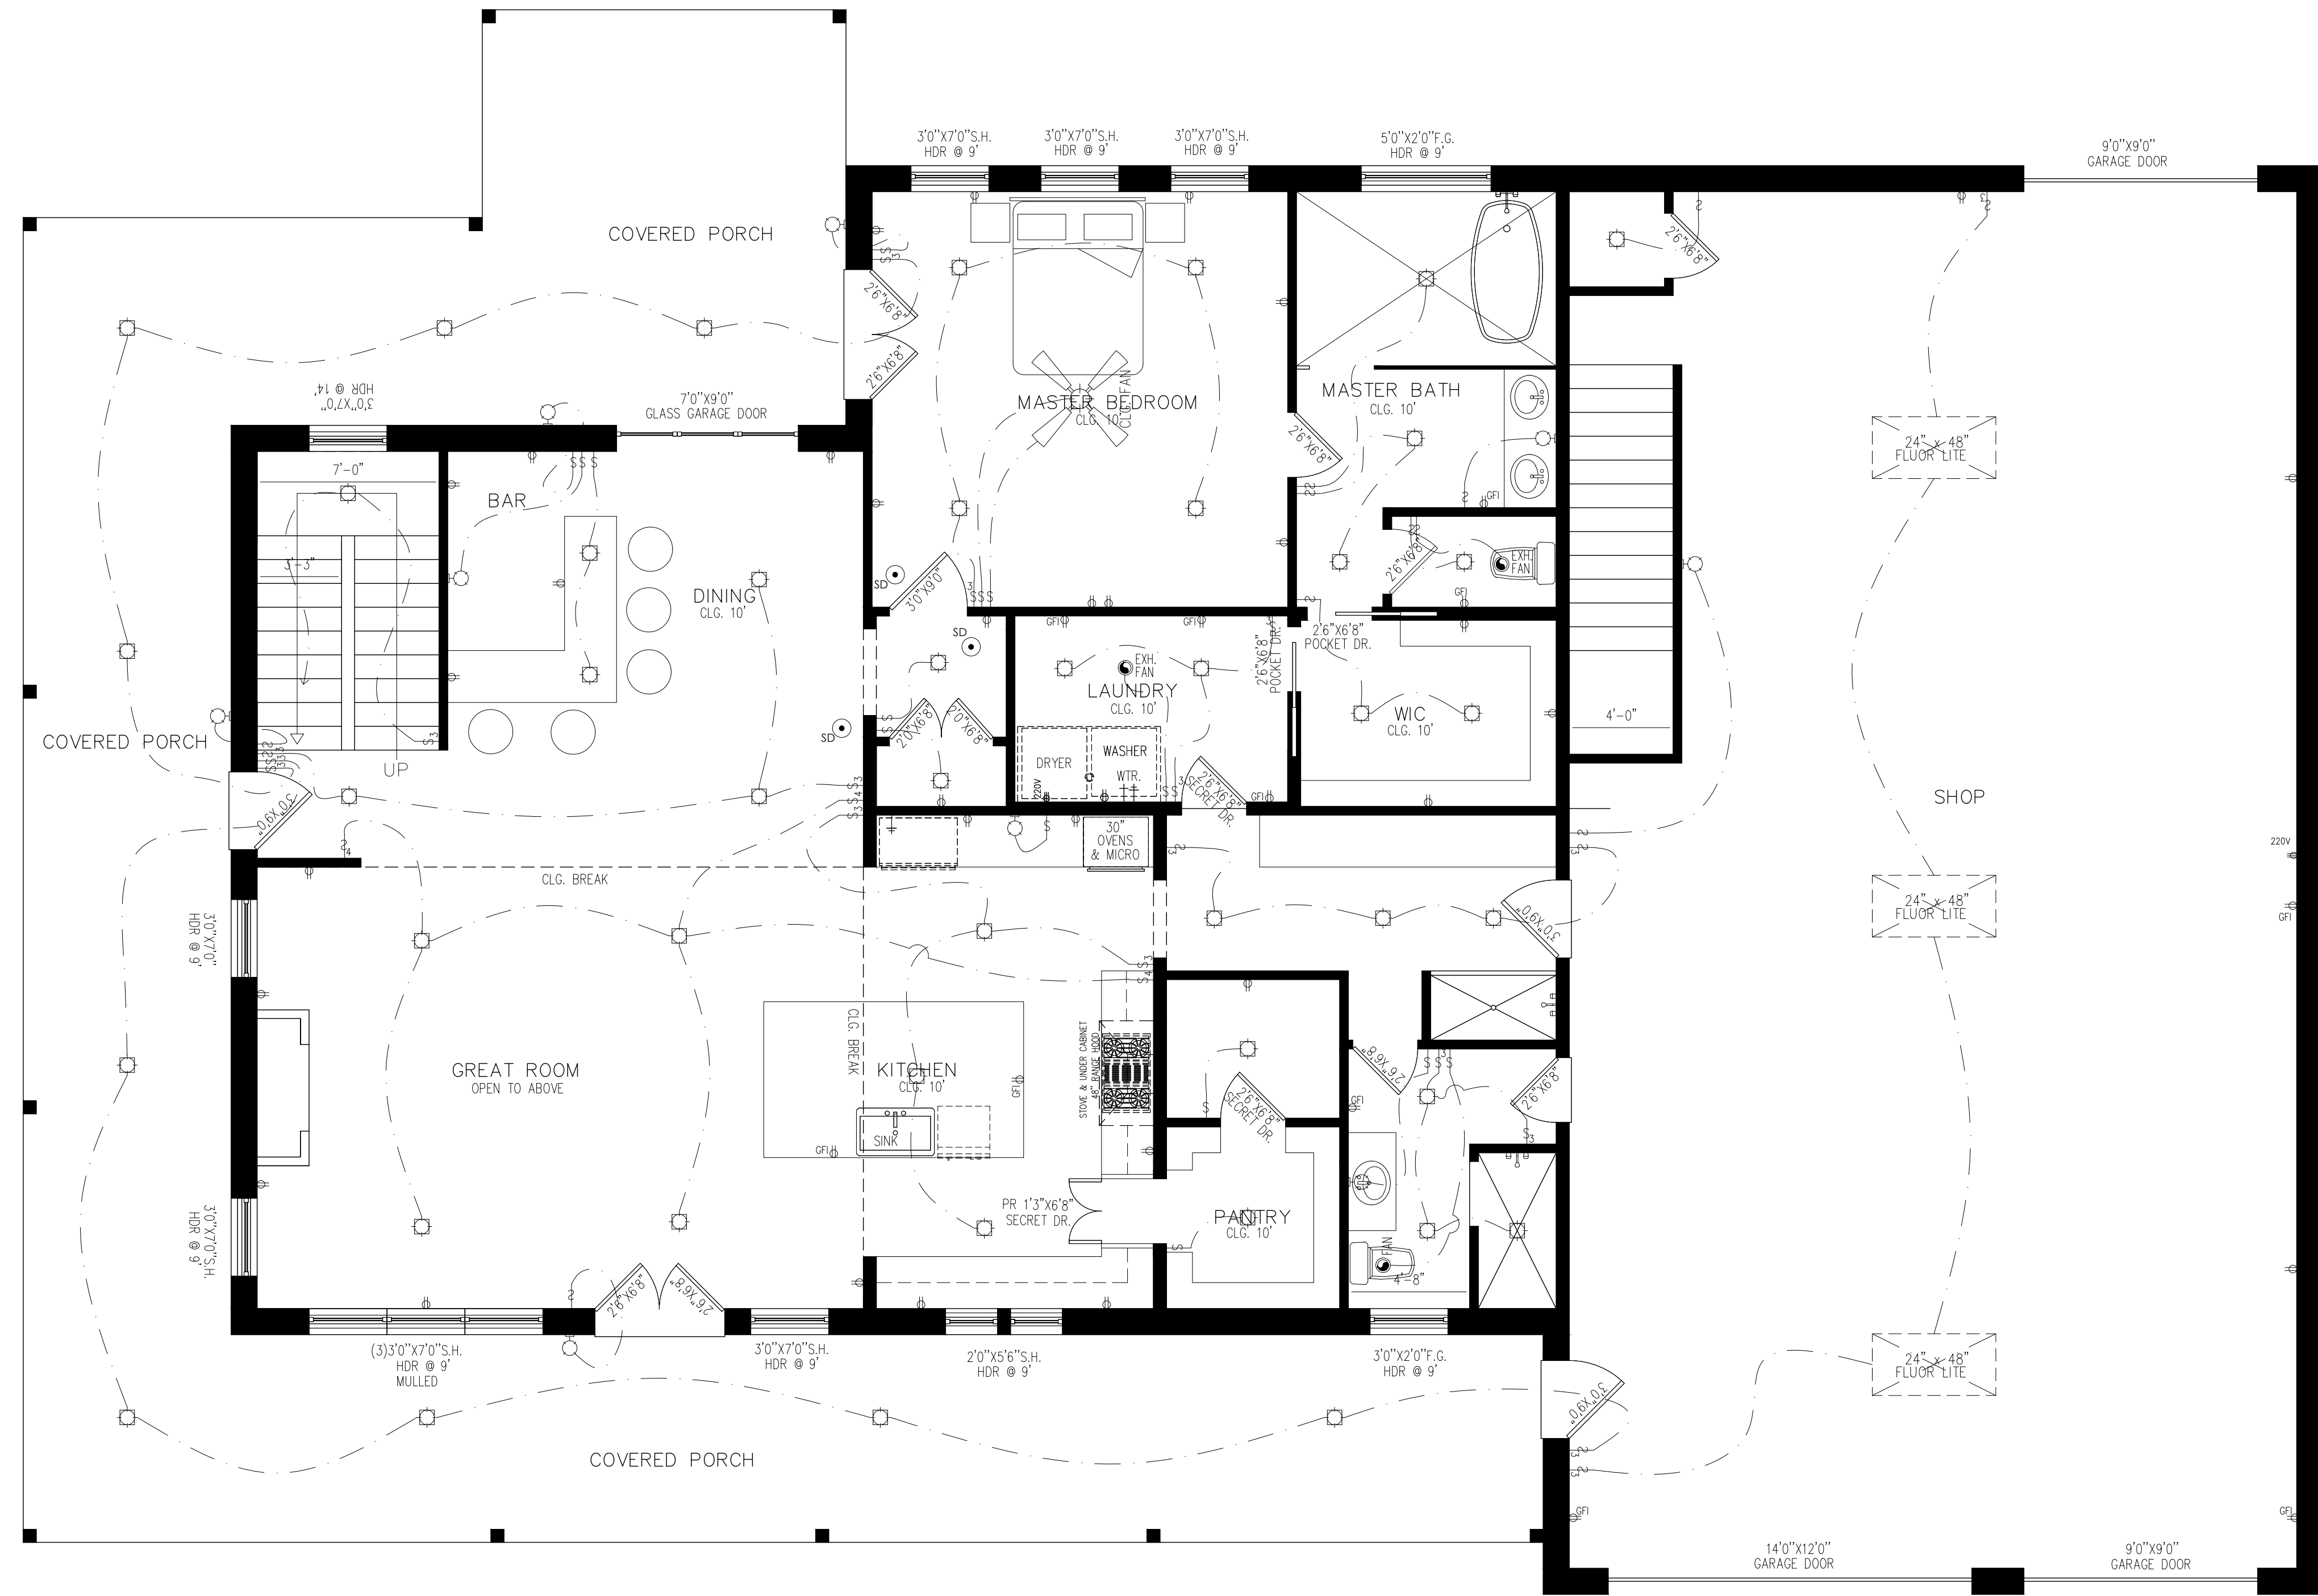

ELEC. FIRST FLOOR PLAN
SCALE: 1/4" = 1'-0"


DARIN DODD

SHEET TITLE
ELECTRICAL PLAN

FLOW
DESIGN FIRM
BARNDOPLANS.COM

A.3
SHEET: 3 OF 5

DISCLAIMER: SUBSTANTIAL EFFORT & CARE HAS BEEN PUT INTO THE CREATION OF THE DESIGN OF THESE PLANS. HOWEVER, SINCE WE CANNOT PROVIDE 100% SITE CONSULTATION, SUPERVISION, OR CONTROL OVER THE ACTUAL CONSTRUCTION AND BECAUSE OF VARIANCES IN LOCAL BUILDING CODES & REQUIREMENTS, BUILDING PRACTICES AND SOIL, CLIMATE, WEATHER AND OTHER CONDITIONS WE CANNOT MAKE ANY WARRANTY, EXPRESSED OR IMPLIED. THE DESIGNER ASSUMES NO RESPONSIBILITIES FOR DAMAGES, INCLUDING STRUCTURAL FAILURES DUE TO ANY DEFENSELESS ERRORS OR OMISSIONS IN THE DESIGN OF THESE PLANS. IT IS RECOMMENDED THAT BEFORE YOU START, CONSULT A LICENSED BUILDER OR ENGINEER OF YOUR CHOICE AND CHECK WITH YOUR LOCAL BUILDING OFFICIALS.

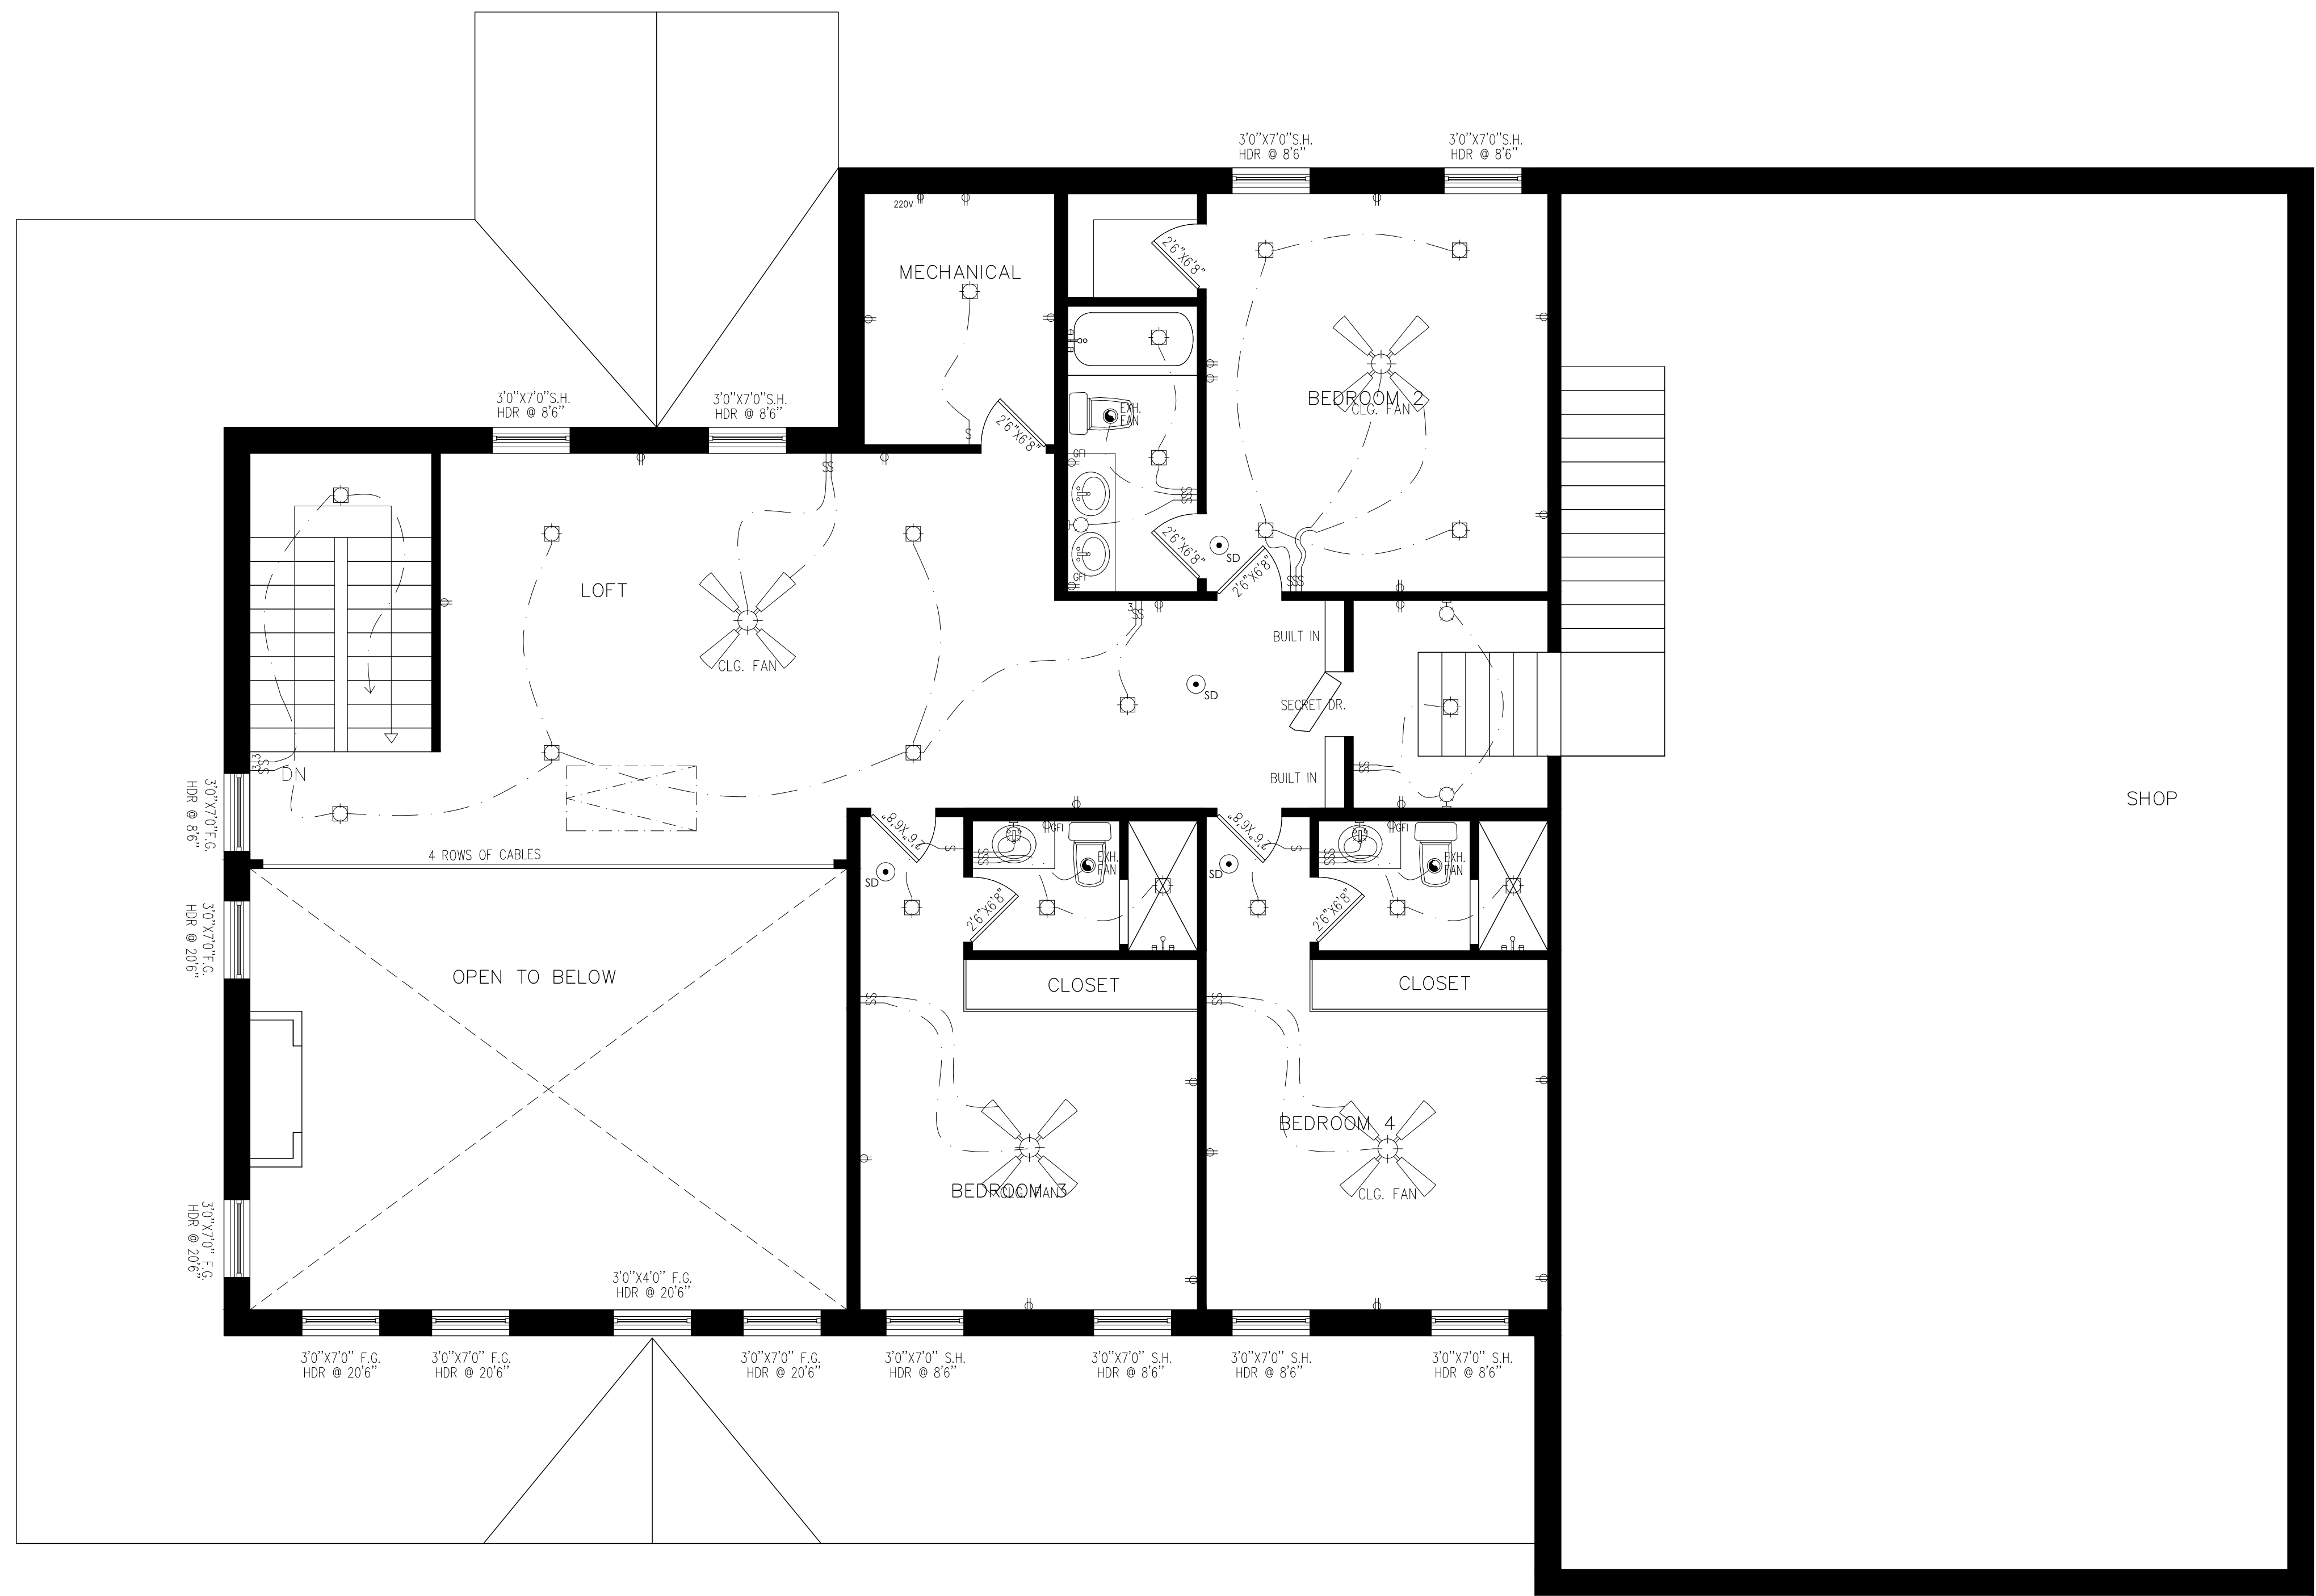


ELEC. UPPER FLOOR PLAN
SCALE: 1/4"=1'-0"

DARIN DODD

SHEET TITLE
ELECTRICAL UPPER
FLOOR PLAN
FLOW
DESIGN FIRM
BARNDOPLANS.COM

A. 4
SHEET: 4 OF 5

DISCLAIMER: SUBSTANTIAL EFFORT & CARE HAS BEEN PUT INTO THE CREATION OF THE DESIGN OF THESE PLANS. HOWEVER, SINCE WE CANNOT PROVIDE 100% SITE CONSULTATION, SUPERVISION, OR CONTROL OVER THE ACTUAL CONSTRUCTION AND BECAUSE OF VARIANCES IN LOCAL BUILDING CODES & REQUIREMENTS, BUILDING PRACTICES AND SOIL, SEISMIC, WEATHER AND OTHER CONDITIONS WE CANNOT MAKE ANY WARRANTY, EXPRESSED OR IMPLIED. THE DESIGNER ASSUMES NO RESPONSIBILITIES FOR DAMAGES, INCLUDING STRUCTURAL FAILURES DUE TO ANY DEFICIENCIES, ERRORS OR OMISSIONS IN THE DESIGN OF THESE PLANS. IT IS RECOMMENDED THAT BEFORE YOU START, CONSULT A LICENSED BUILDER OR ENGINEER OF YOUR CHOICE AND CHECK WITH YOUR LOCAL BUILDING OFFICIALS.

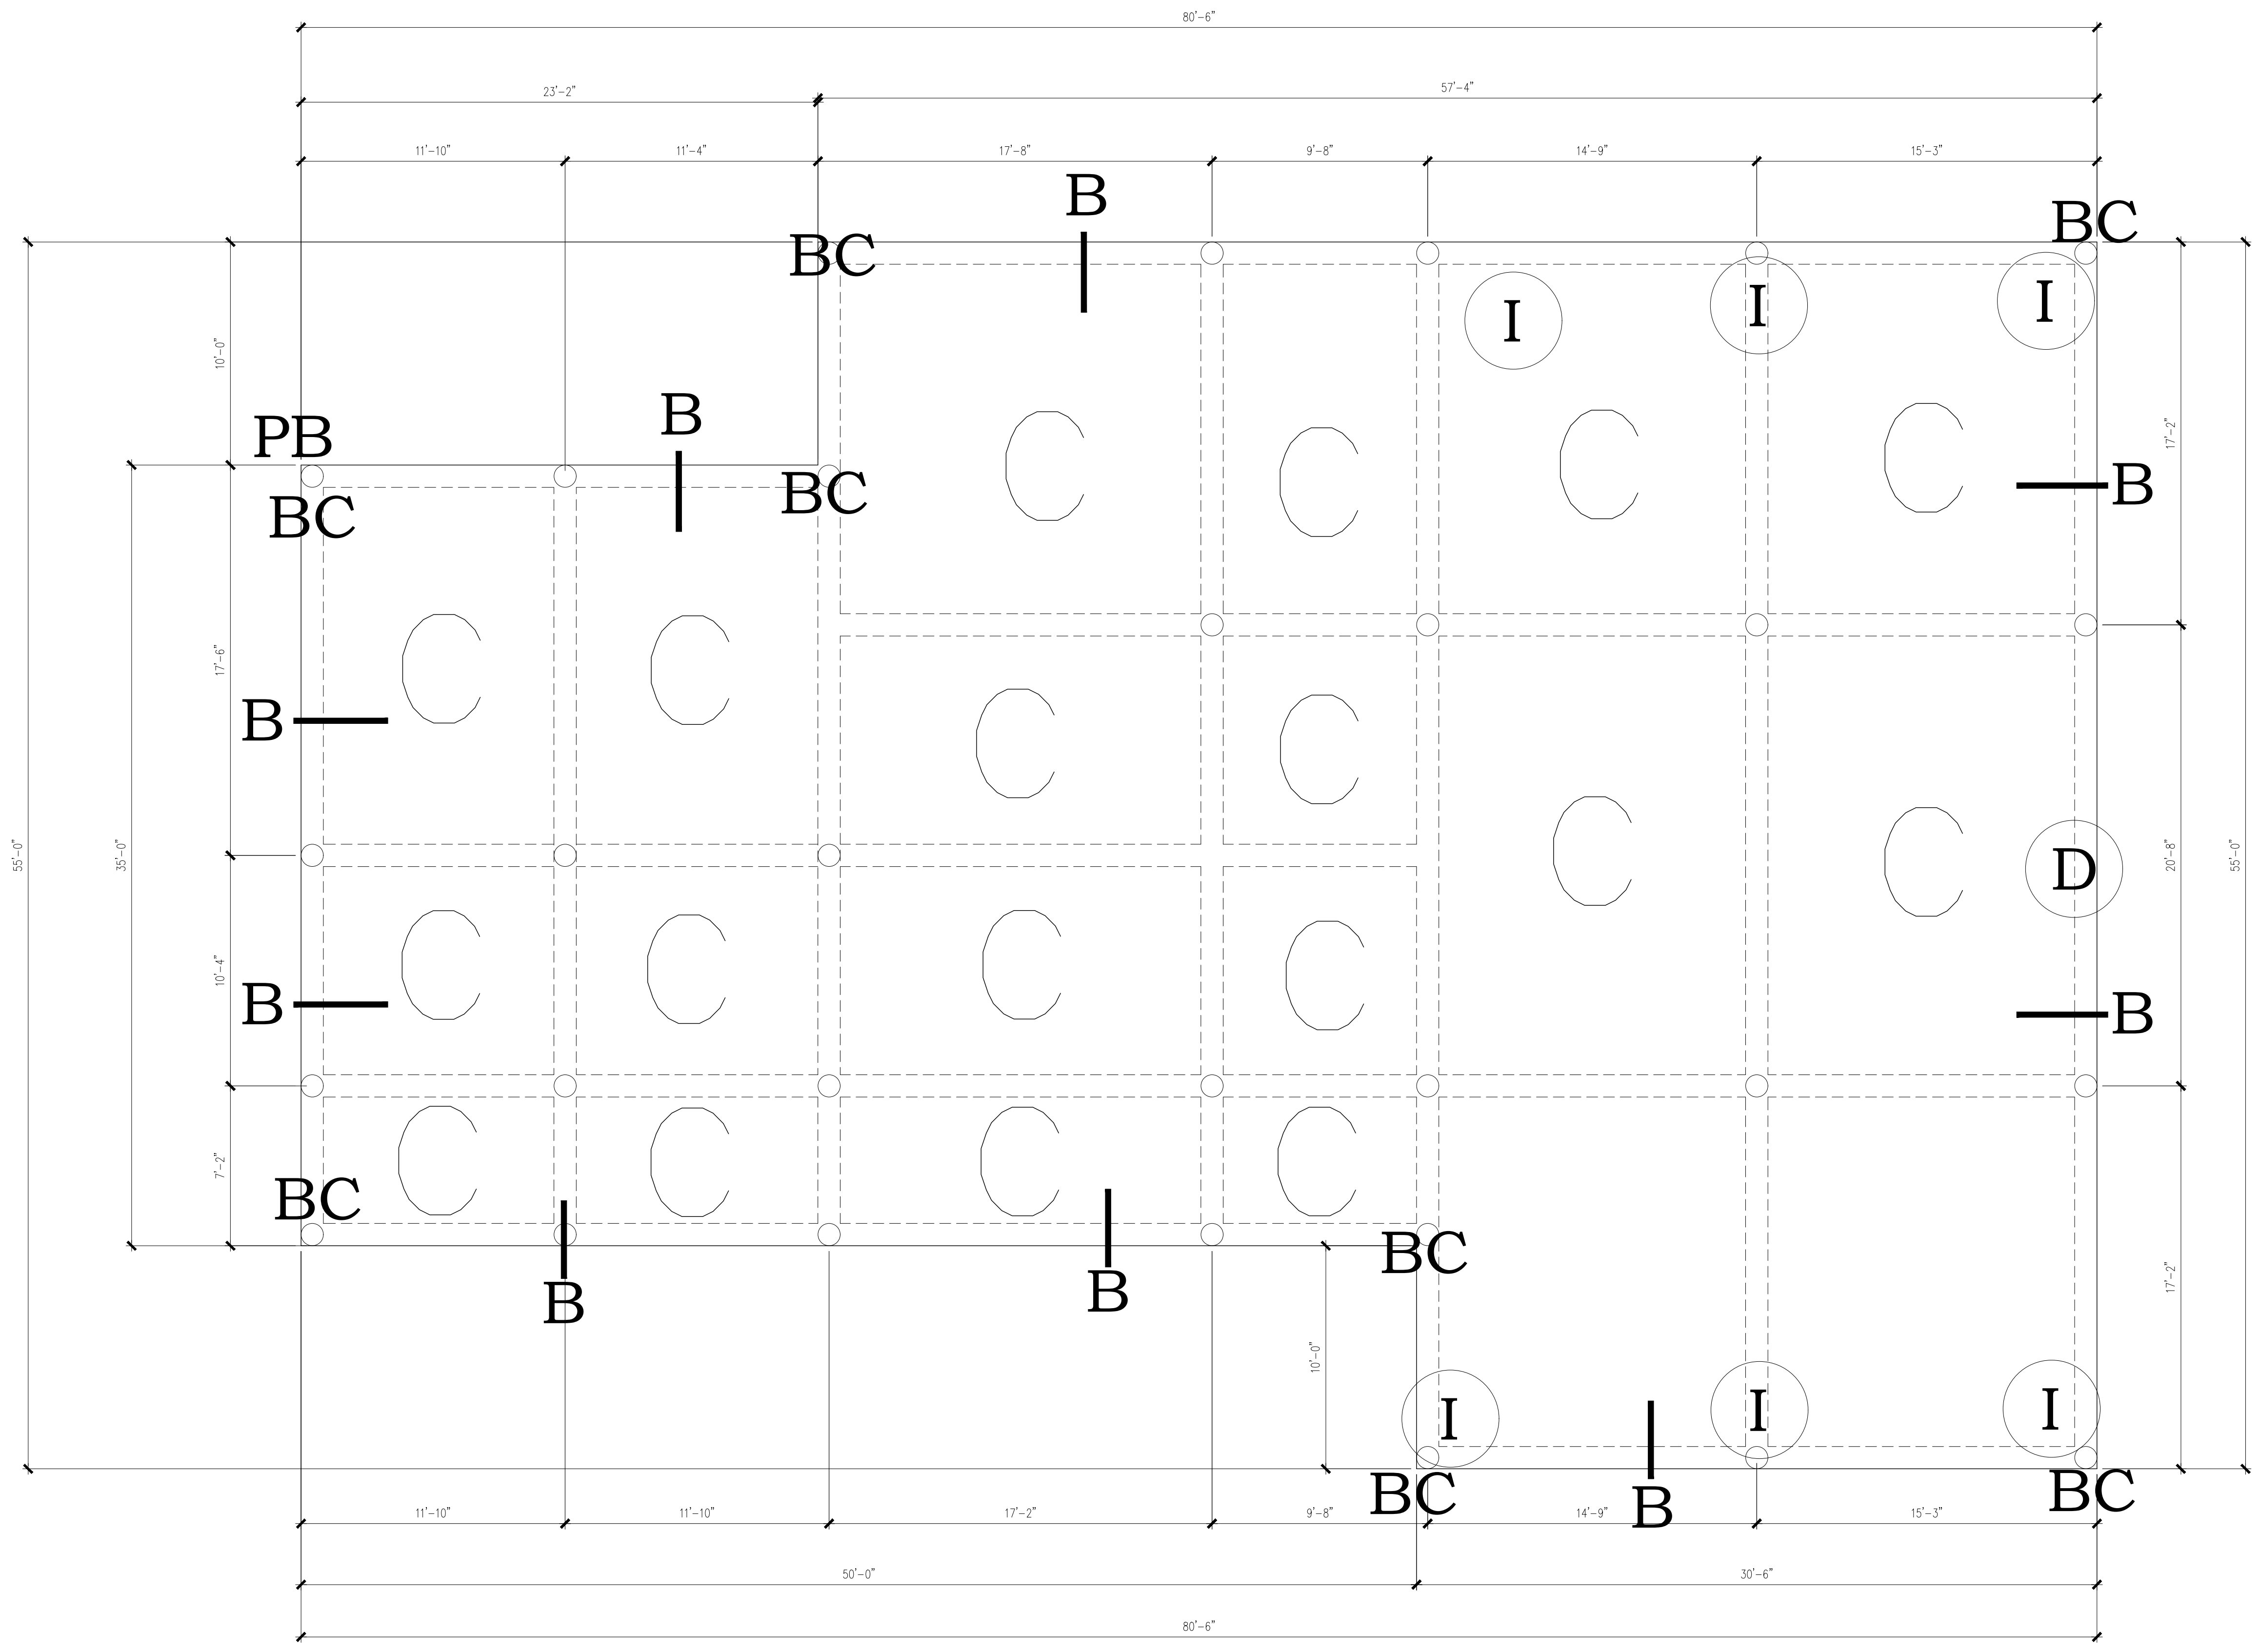

FOUNDATION PLAN
SCALE: 1/4"=1'-0"

DARIN DODD

SHEET TITLE
FOUNDATION
PLAN
FLOW
DESIGN FIRM
BARNDOPLANS.COM

A.5
SHEET: 5 OF 5